



101.1 DINING ROOM POWER PLAN
SCALE: 1/8" = 1'-0"

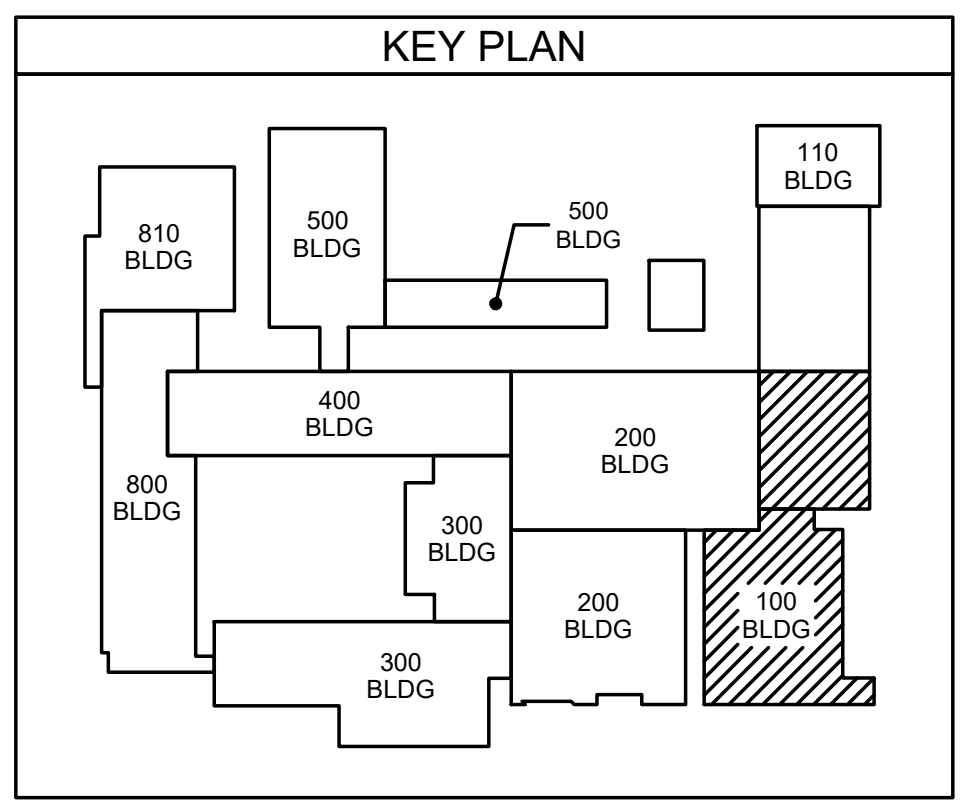

No.	Date	Revision
1	11/17/23	ADDENDUM # 1
2	11/14/23	ADDENDUM # 2
3	11/21/23	ADDENDUM # 3

Hite associates
ARCHITECTURE / PLANNING / TECHNOLOGY
2600 Meridian Drive / Greenville, NC 27834 / tel (252) 757-0333

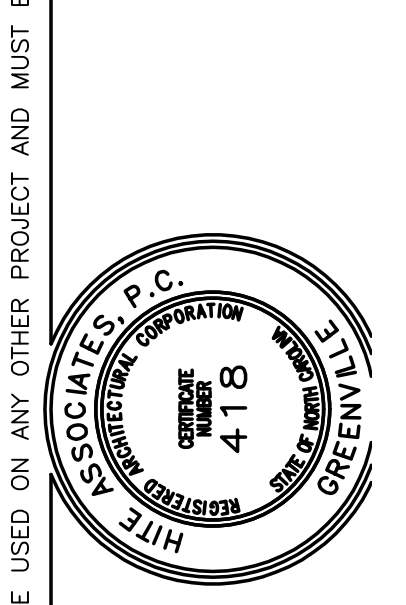

New Additions & Renovations to
West Carteret High School
4700 Country Club Road, Morehead City, NC 28577
Carteret County Schools / North Carolina

Project No. 22112
Date: 03 Oct 2023
Drawing No. **E 101**

ES Project No. ES21080
ENGINEERING
SOURCE OF NC, PA.
102-42 Rapunzel Blvd., Greenville, NC 27834
E-Mail Address: general@hiteassociates.com
Tel (252) 432-0333 • Fax (252) 432-0462 • TDD (252) 432-0333

D. Hite
11/21/23
D. Hite
P.E.