



**811.1 NEW GYM POWER PLAN**  
SCALE: 1/8" = 1'-0"

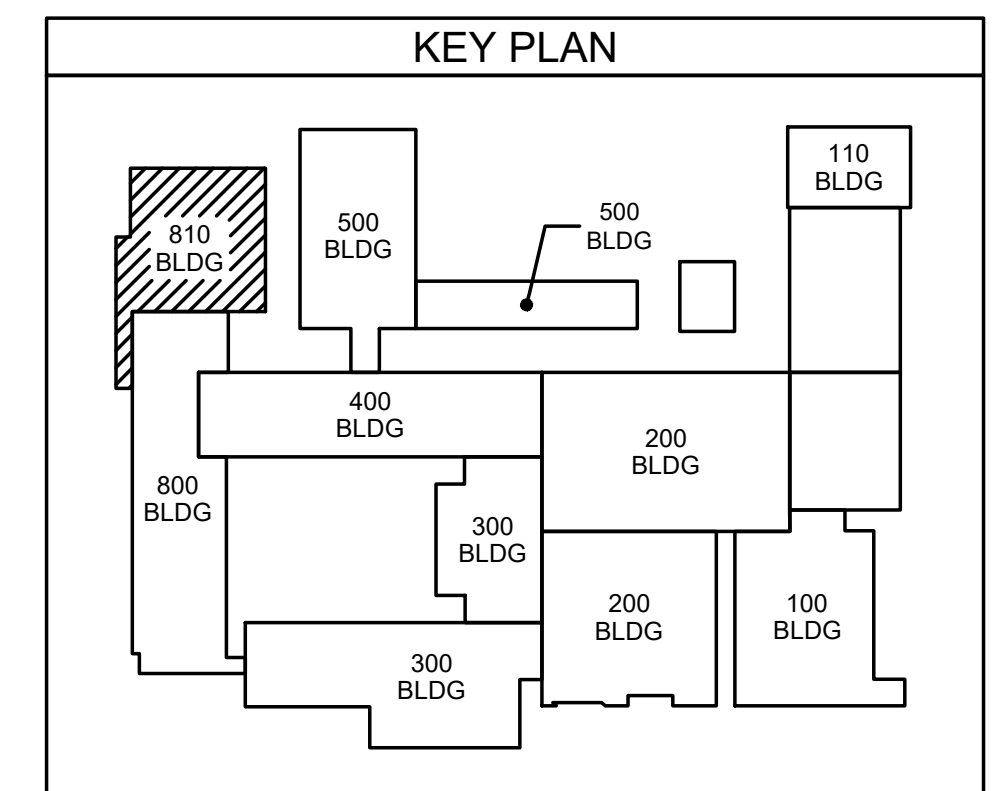

**POWER PLAN NOTES:**  
 ① CONTROLLED ACCESS ELECTRIC STRIKE DOOR. SEE DOOR SCHEDULE AND COORD REQTS WITH IT CONTRACTOR.

1	12/01/23	ADDENDUM # 6
2	1/27/23	ADDENDUM # 4
3	1/27/23	ADDENDUM # 3
4	1/17/23	ADDENDUM # 2
5	1/19/23	ADDENDUM # 1
Rev	Date	Revision


**Hite associates**  
 ARCHITECTURE / PLANNING / TECHNOLOGY  
 2600 Meridian Drive / Greenville, NC 27834 / tel (252) 757-0333

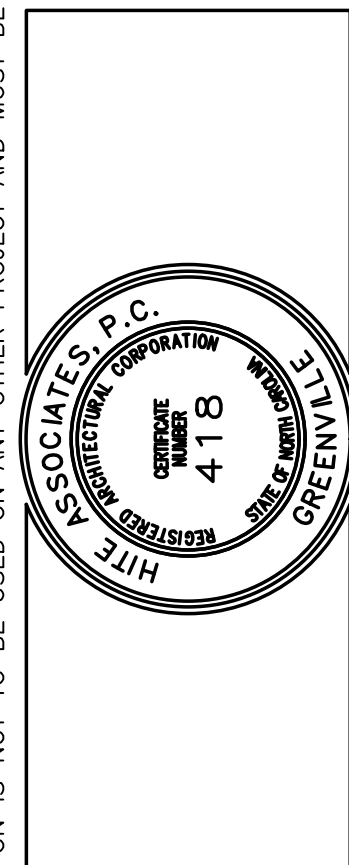

New Additions & Renovations to  
**West Carteret High School**  
 4700 Country Club Road, Morehead City NC 28577  
 Carteret County Schools / North Carolina

Project No.	22112
Date	03 Oct 2023
Drawing no.	<b>E 811</b>

**ENGINEERING**  
 SOURCE OF NC, PA.  
 102-A0 Regency Blvd, Greenville, NC 27834  
 E-Mail Address: general@engrsource.com  
 Tel (252) 439-0338 • Fax (252) 439-0462 • TDD (252) 439-0338

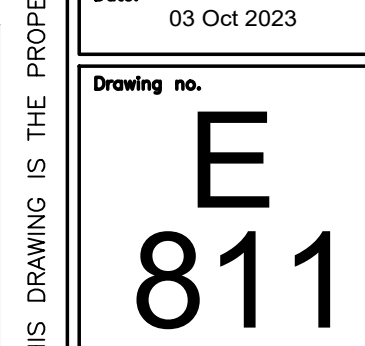

102-A0 Regency Blvd, Greenville, NC 27834  
 E-Mail Address: general@engrsource.com  
 Tel (252) 439-0338 • Fax (252) 439-0462 • TDD (252) 439-0338