



111.2 VOCATIONAL BUILDING FIRE ALARM PLAN
SCALE: 1/8" = 1'-0"

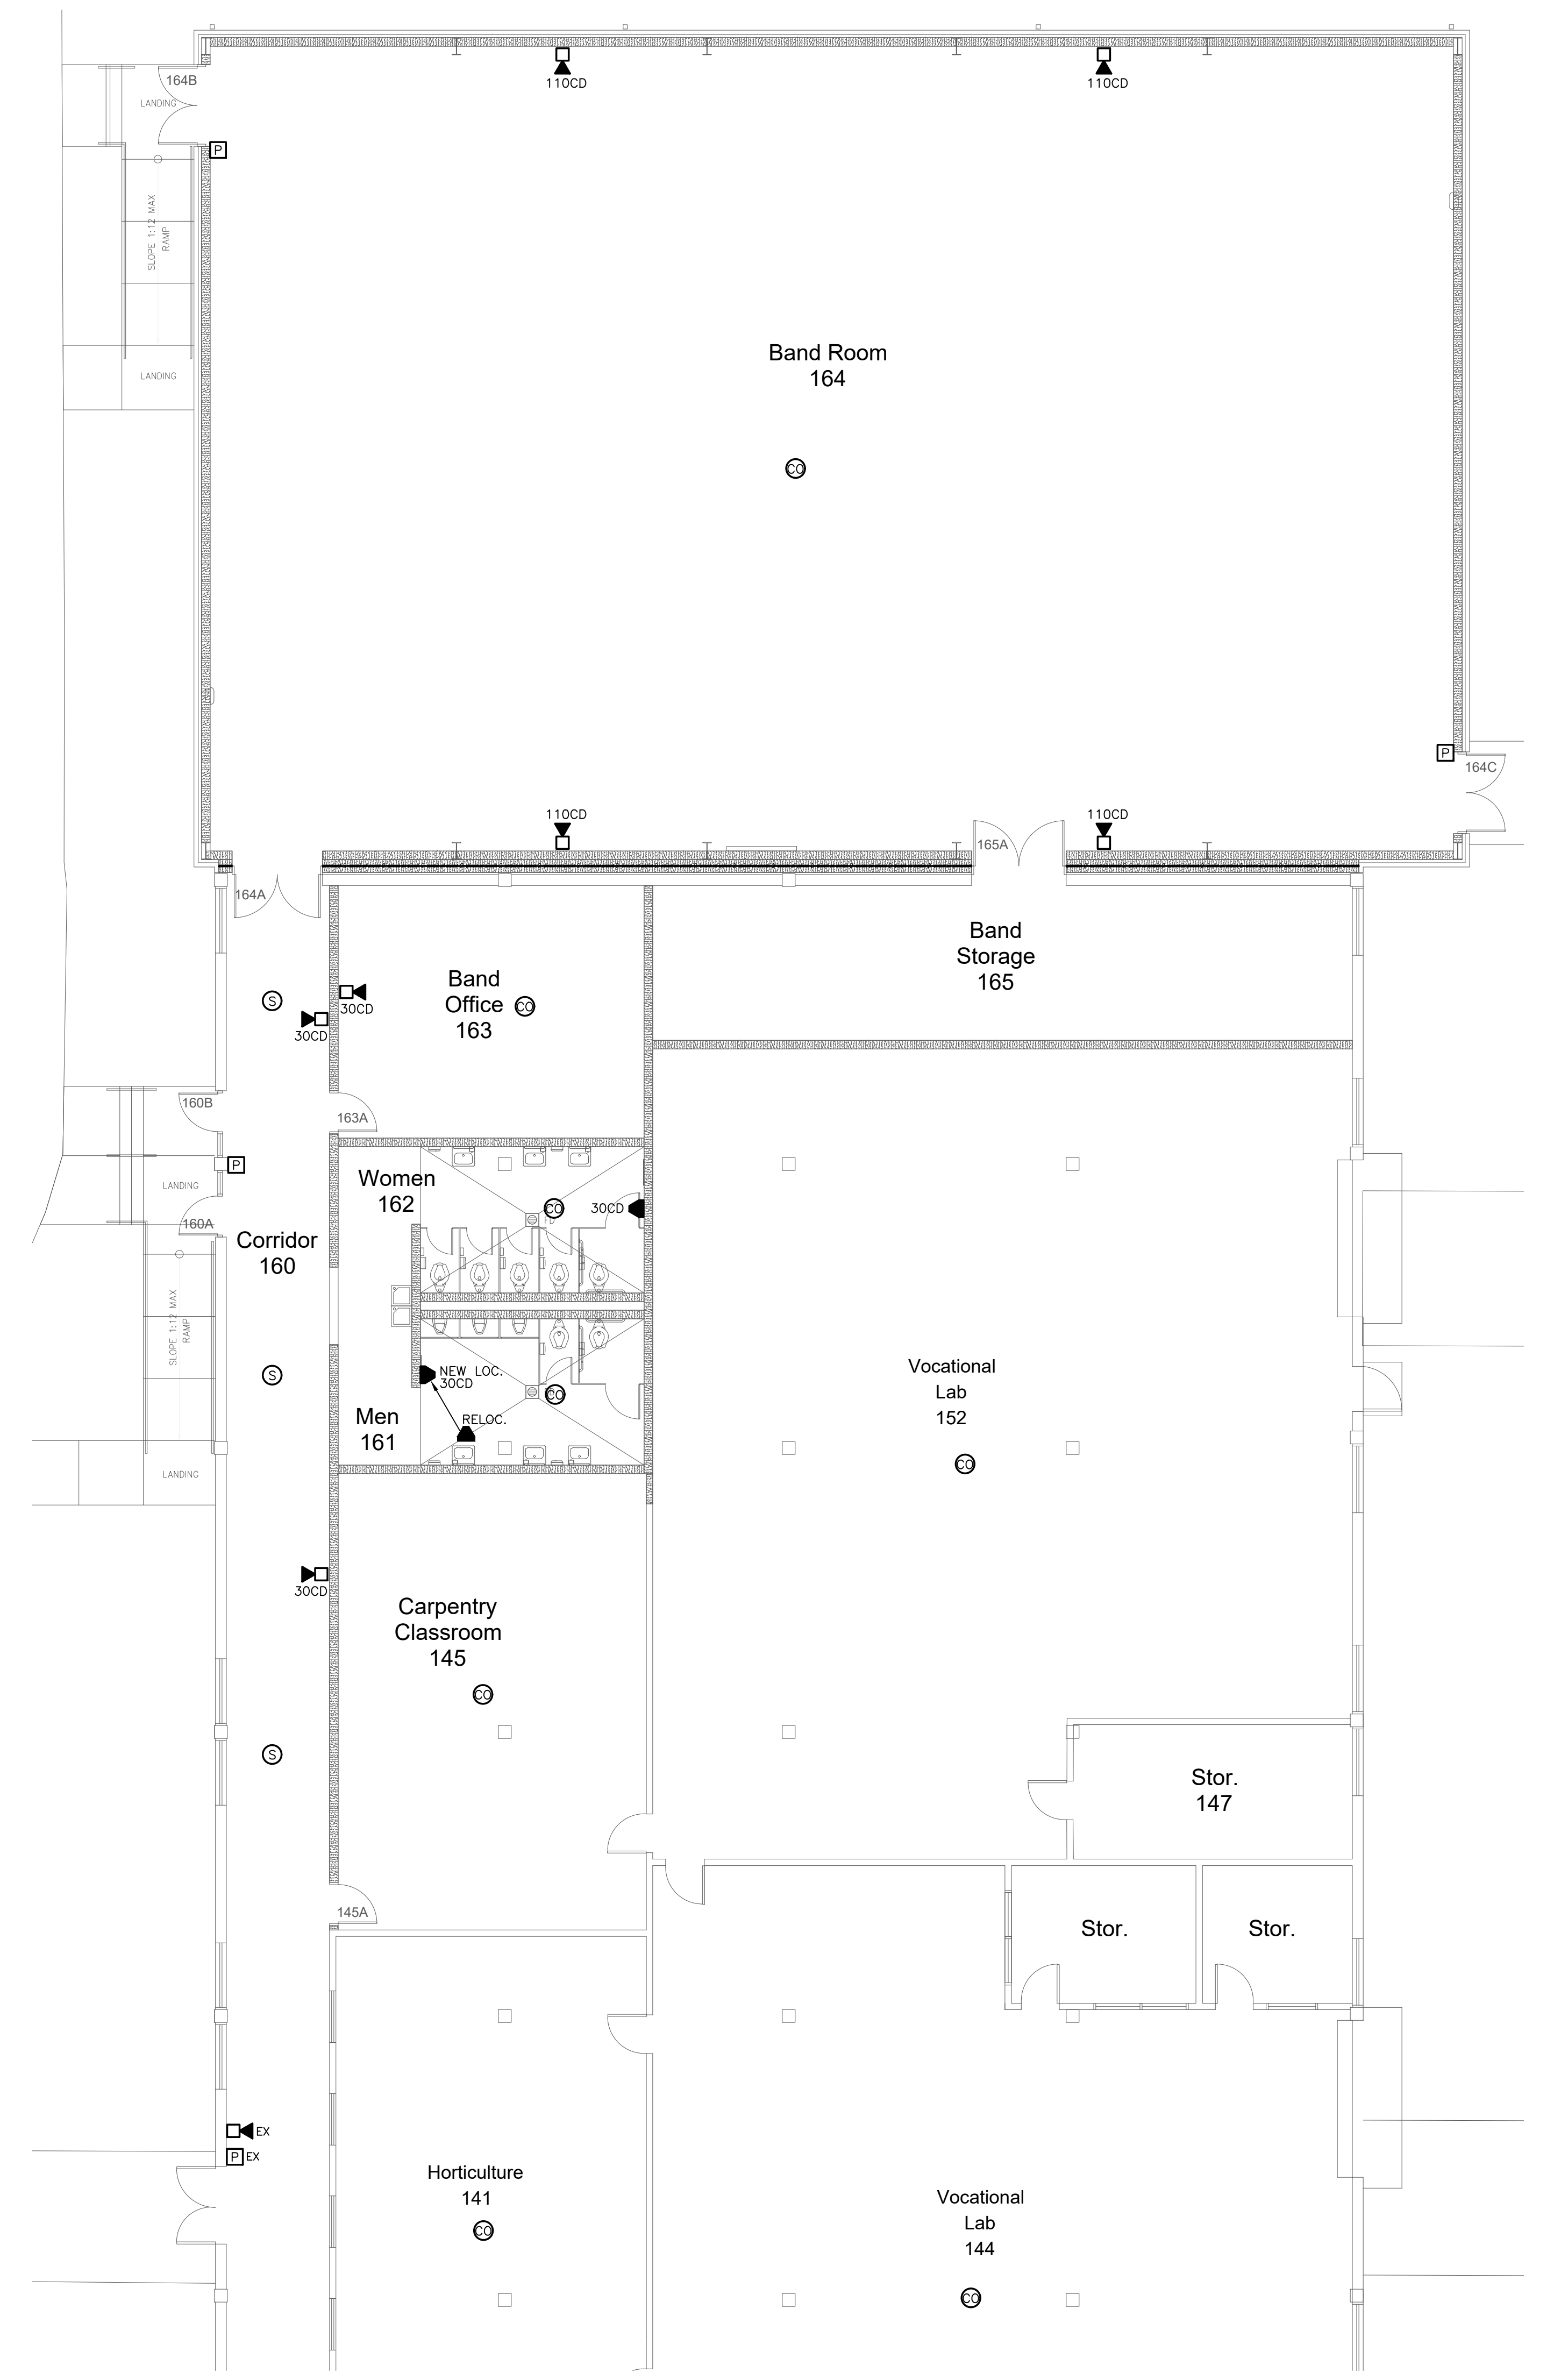

111.1 BAND RM ADD'N FIRE ALARM PLAN
SCALE: 1/8" = 1'-0"

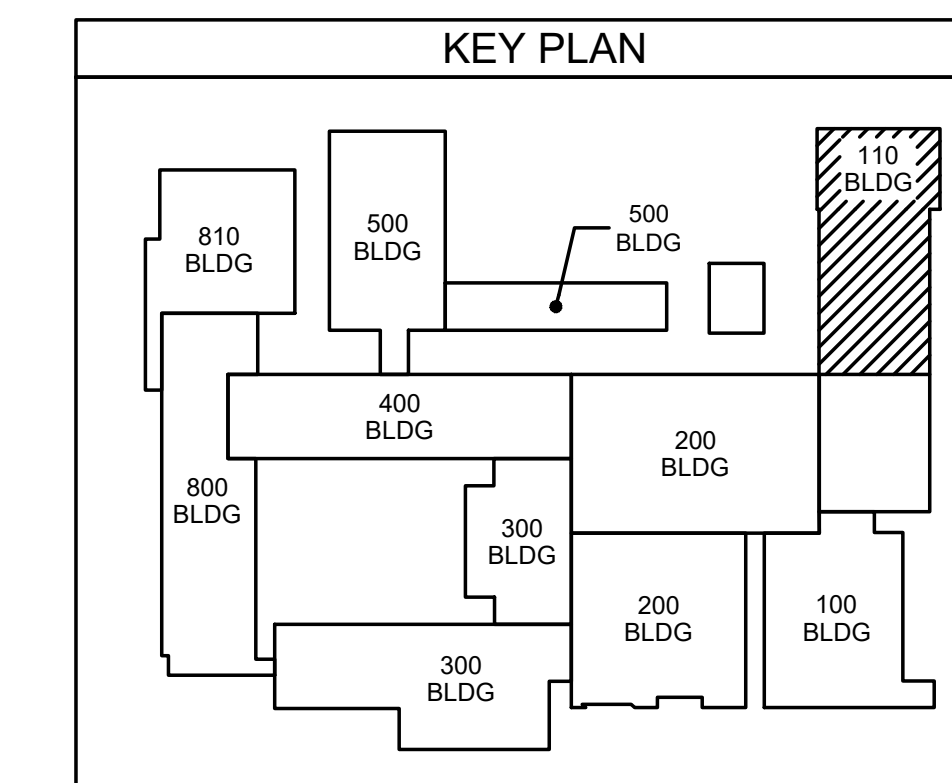


ENGINEERING
SOURCE OF NC, P.A.

102-42 Regency Blvd., Greenville, NC 27834
E-Mail Address: general@hiteassociates.com
Tel (252) 432-0328 • Fax (252) 432-0462 • TDD (252) 432-0328

D. Wilson
11/27/23

No.	Date	Revision
1	11/09/23	ADDENDUM # 1
2	11/14/23	ADDENDUM # 2
3	11/21/23	ADDENDUM # 3
4	11/27/23	ADDENDUM # 4

Hite associates
ARCHITECTURE / PLANNING / TECHNOLOGY
2600 Meridian Drive / Greenville, NC 27834 / tel (252) 757-0333

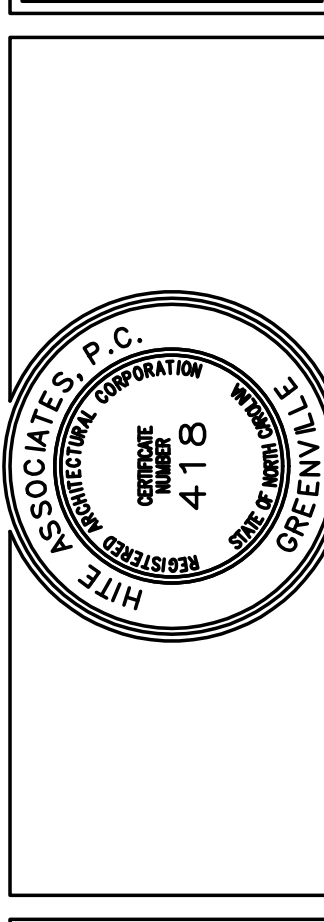

**New Additions & Renovations to
West Carteret High School**
4700 Country Club Road, Morehead City, NC 28577
Carteret County Schools / North Carolina

Project No. 22112
Date: 03 Oct 2023
Drawing No. **FA 111**

THIS DRAWING IS THE PROPERTY OF ENGINEERING SOURCE OF NC, P.A. THIS DRAWING IS NOT TO BE COPIED IN WHOLE OR IN PART. THIS DRAWING OR THE INFORMATION HEREUPON IS NOT TO BE USED ON ANY OTHER PROJECT AND MUST BE RETURNED TO ENGINEERING SOURCE OF NC, P.A. UPON REQUEST. DO NOT SCALE THESE DRAWINGS. REFER TO ARCHITECTURAL DRAWINGS FOR EXACT DIMENSIONS.