




**201.1 LOCKER ROOM FIRE ALARM PLAN**  
SCALE: 1/8" = 1'-0"

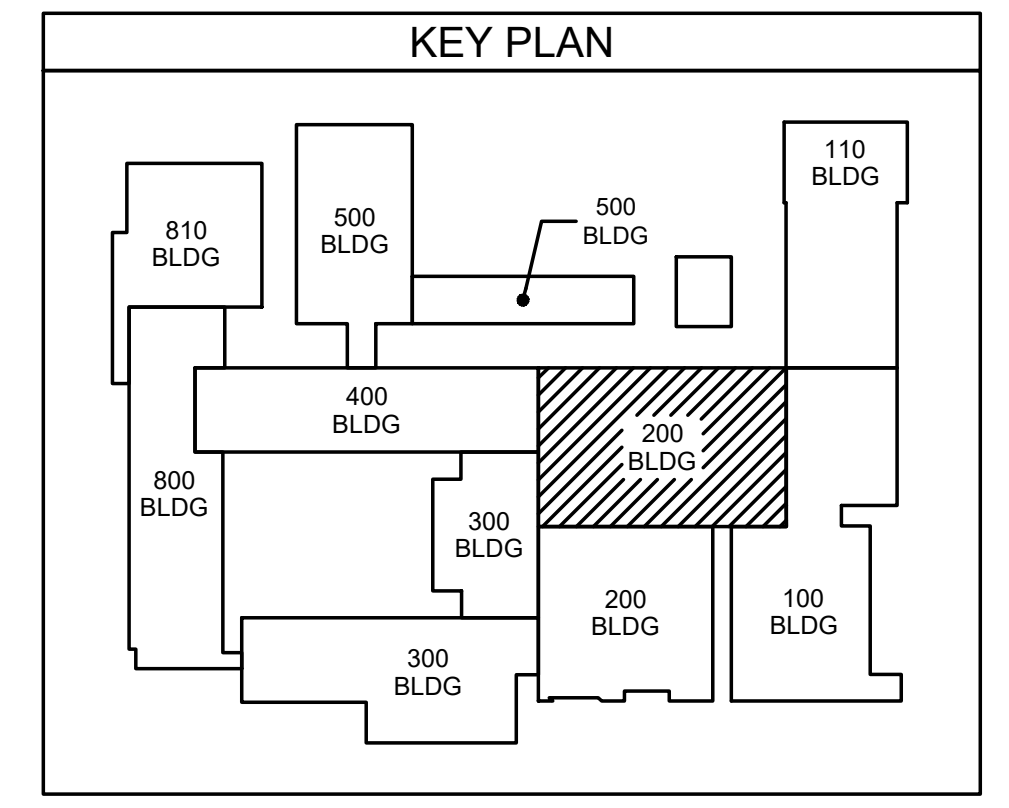

**ENGINEERING**  
SOURCE OF NC, PA.

102-42 Regency Blvd. Greensboro, NC 27434  
E-Mail Address: general@hiteassociates.com  
Web (252) 432-0328 • Fax (252) 432-0462 • Telex P-1973

*D. Wilson*  
11/27/23  
WILSON FOU

This drawing is the property of Engineering Source of NC, P.A. This drawing is not to be copied in whole or in part. This drawing or the information hereupon is not to be used on any other project and must be returned to Engineering Source of NC, P.A. upon request. Do not scale these drawings. Refer to architectural drawings for exact dimensions.

**Hite associates**  
ARCHITECTURE / PLANNING / TECHNOLOGY  
2600 Meridian Drive / Greenville, NC 27834 / Tel (252) 757-0333

**New Additions & Renovations to  
West Carteret High School**  
4700 Country Club Road, Morehead City, NC 28577  
Carteret County Schools / North Carolina

Project No. 22112  
Date: 03 Oct 2023  
Drawing No. **FA 201**

No.	Date	Revision
1	11/09/23	ADDENDUM # 1
2	11/14/23	ADDENDUM # 2
3	11/21/23	ADDENDUM # 3
4	11/27/23	ADDENDUM # 4