



501.2 BASE BID - SCIENCE WING FIRE ALARM PLAN
SCALE: 1/8" = 1'-0"

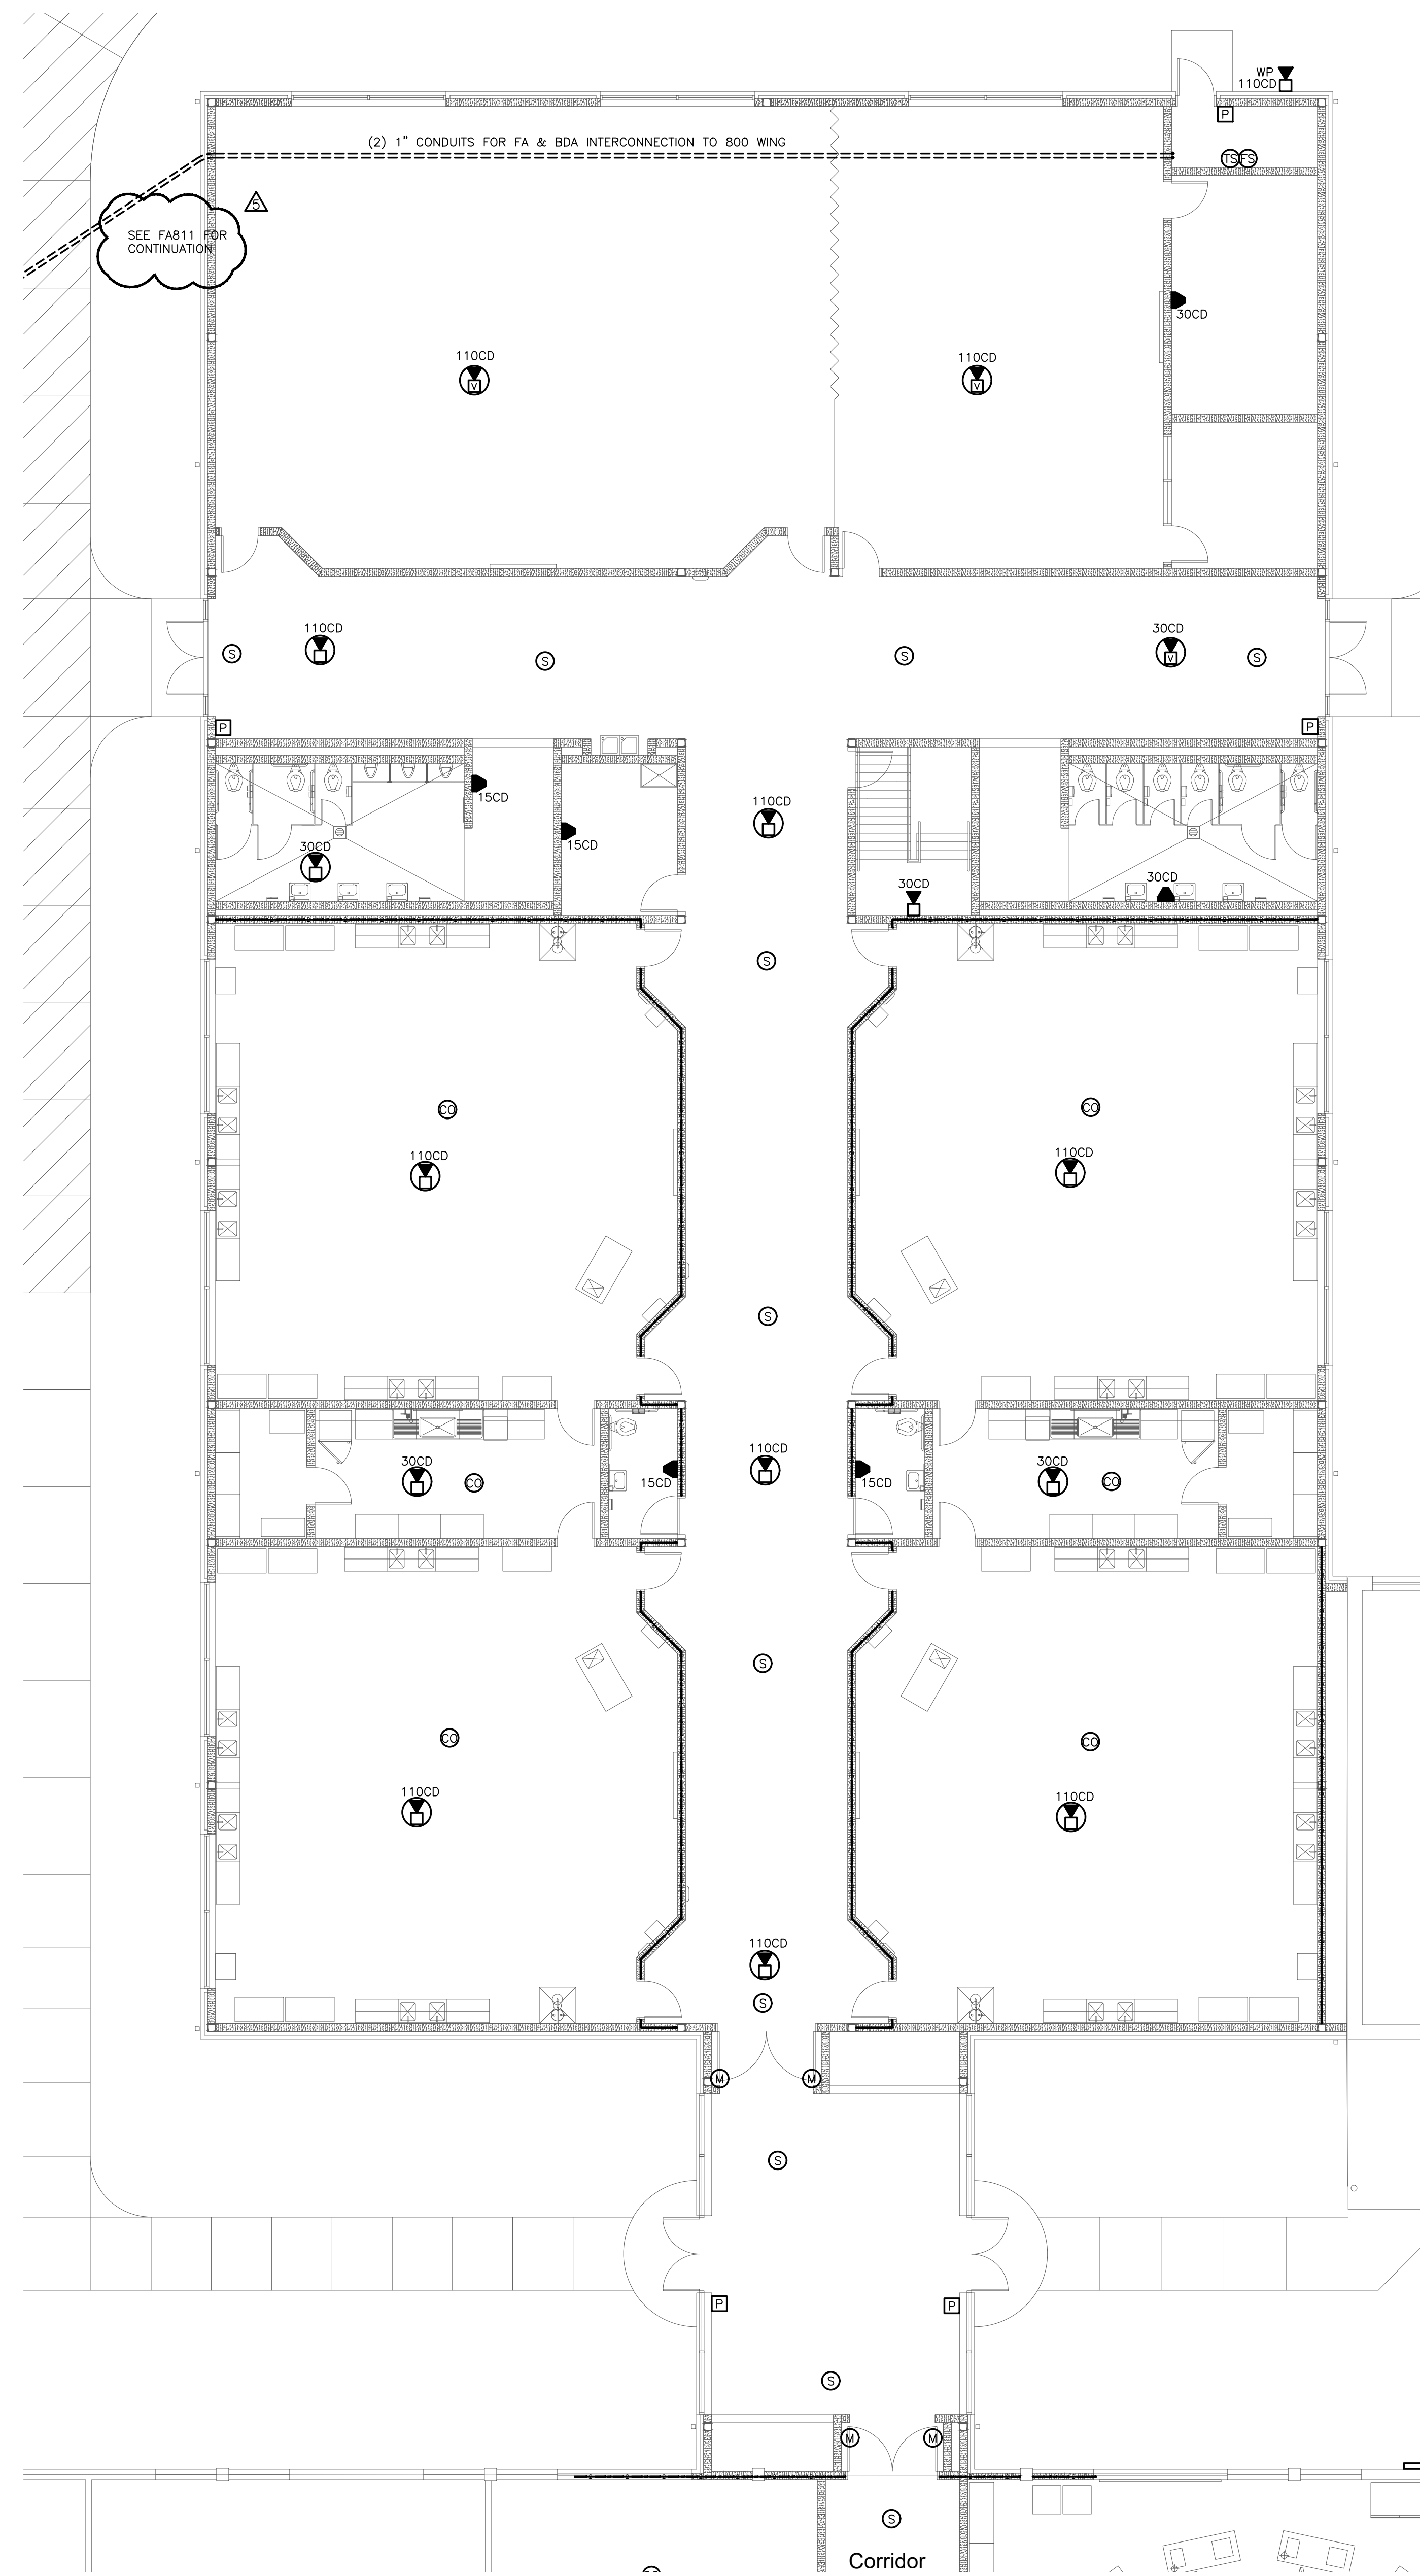

501.1 ALT. BID - SCIENCE WING FIRE ALARM PLAN
SCALE: 1/8" = 1'-0"

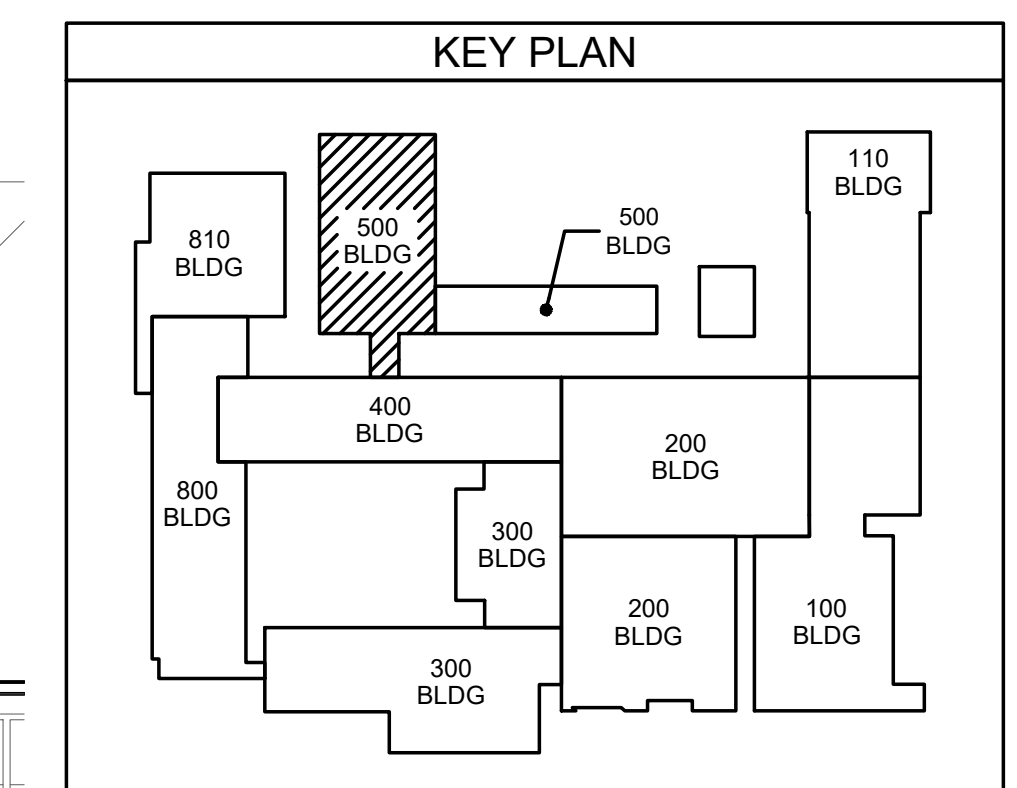


ES21060
ENGINEERING
SOURCE OF NC, P.A.
100-40 Regency Blvd., Greensboro, NC 27834
E-Mail Address: general@engsource.com
Tel: (336) 439-0338 • Fax: (336) 439-0462 • TDD: (336) 439-1073

Professional Engineer
No. 01211123
WILSON J. WILSON, P.E.

THIS DRAWING IS THE PROPERTY OF ENGINEERING SOURCE OF NC, P.A. THIS DRAWING IS NOT TO BE COPIED IN WHOLE OR IN PART. THIS DRAWING OR THE INFORMATION HEREUPON IS NOT TO BE USED ON ANY OTHER PROJECT AND MUST BE RETURNED TO ENGINEERING SOURCE OF NC, P.A. UPON REQUEST. DO NOT SCALE THESE DRAWINGS. REFER TO ARCHITECTURAL DRAWINGS FOR EXACT DIMENSIONS.

Hite associates
ARCHITECTURE / PLANNING / TECHNOLOGY
2600 Meridian Drive / Greenville, NC 27834 / tel: (252) 757-0333

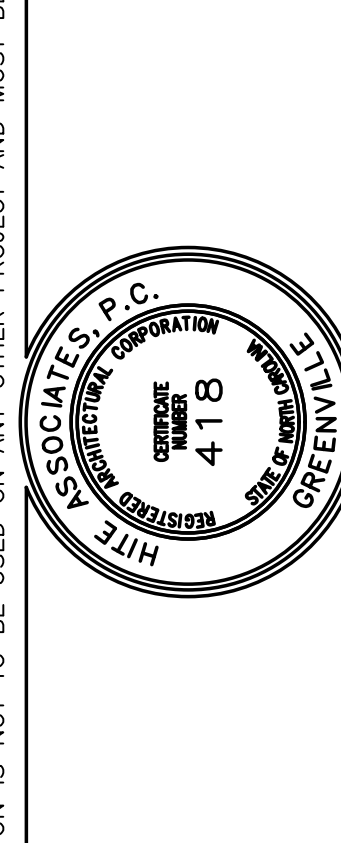

New Additions & Renovations to
West Carteret High School
4700 Country Club Road, Morehead City NC 28577
Carteret County Schools / North Carolina

Project No. 22112
Date: 03 Oct 2023
Drawing No. **FA 501**

No.	Date	Revision
1	12/01/23	ADDENDUM # 6
2	11/27/23	ADDENDUM # 4
3	11/27/23	ADDENDUM # 3
4	11/14/23	ADDENDUM # 2
5	11/09/23	ADDENDUM # 1