



**811.2 BASE BID - GYM FIRE ALARM PLAN**  
SCALE: 1/8" = 1'-0"

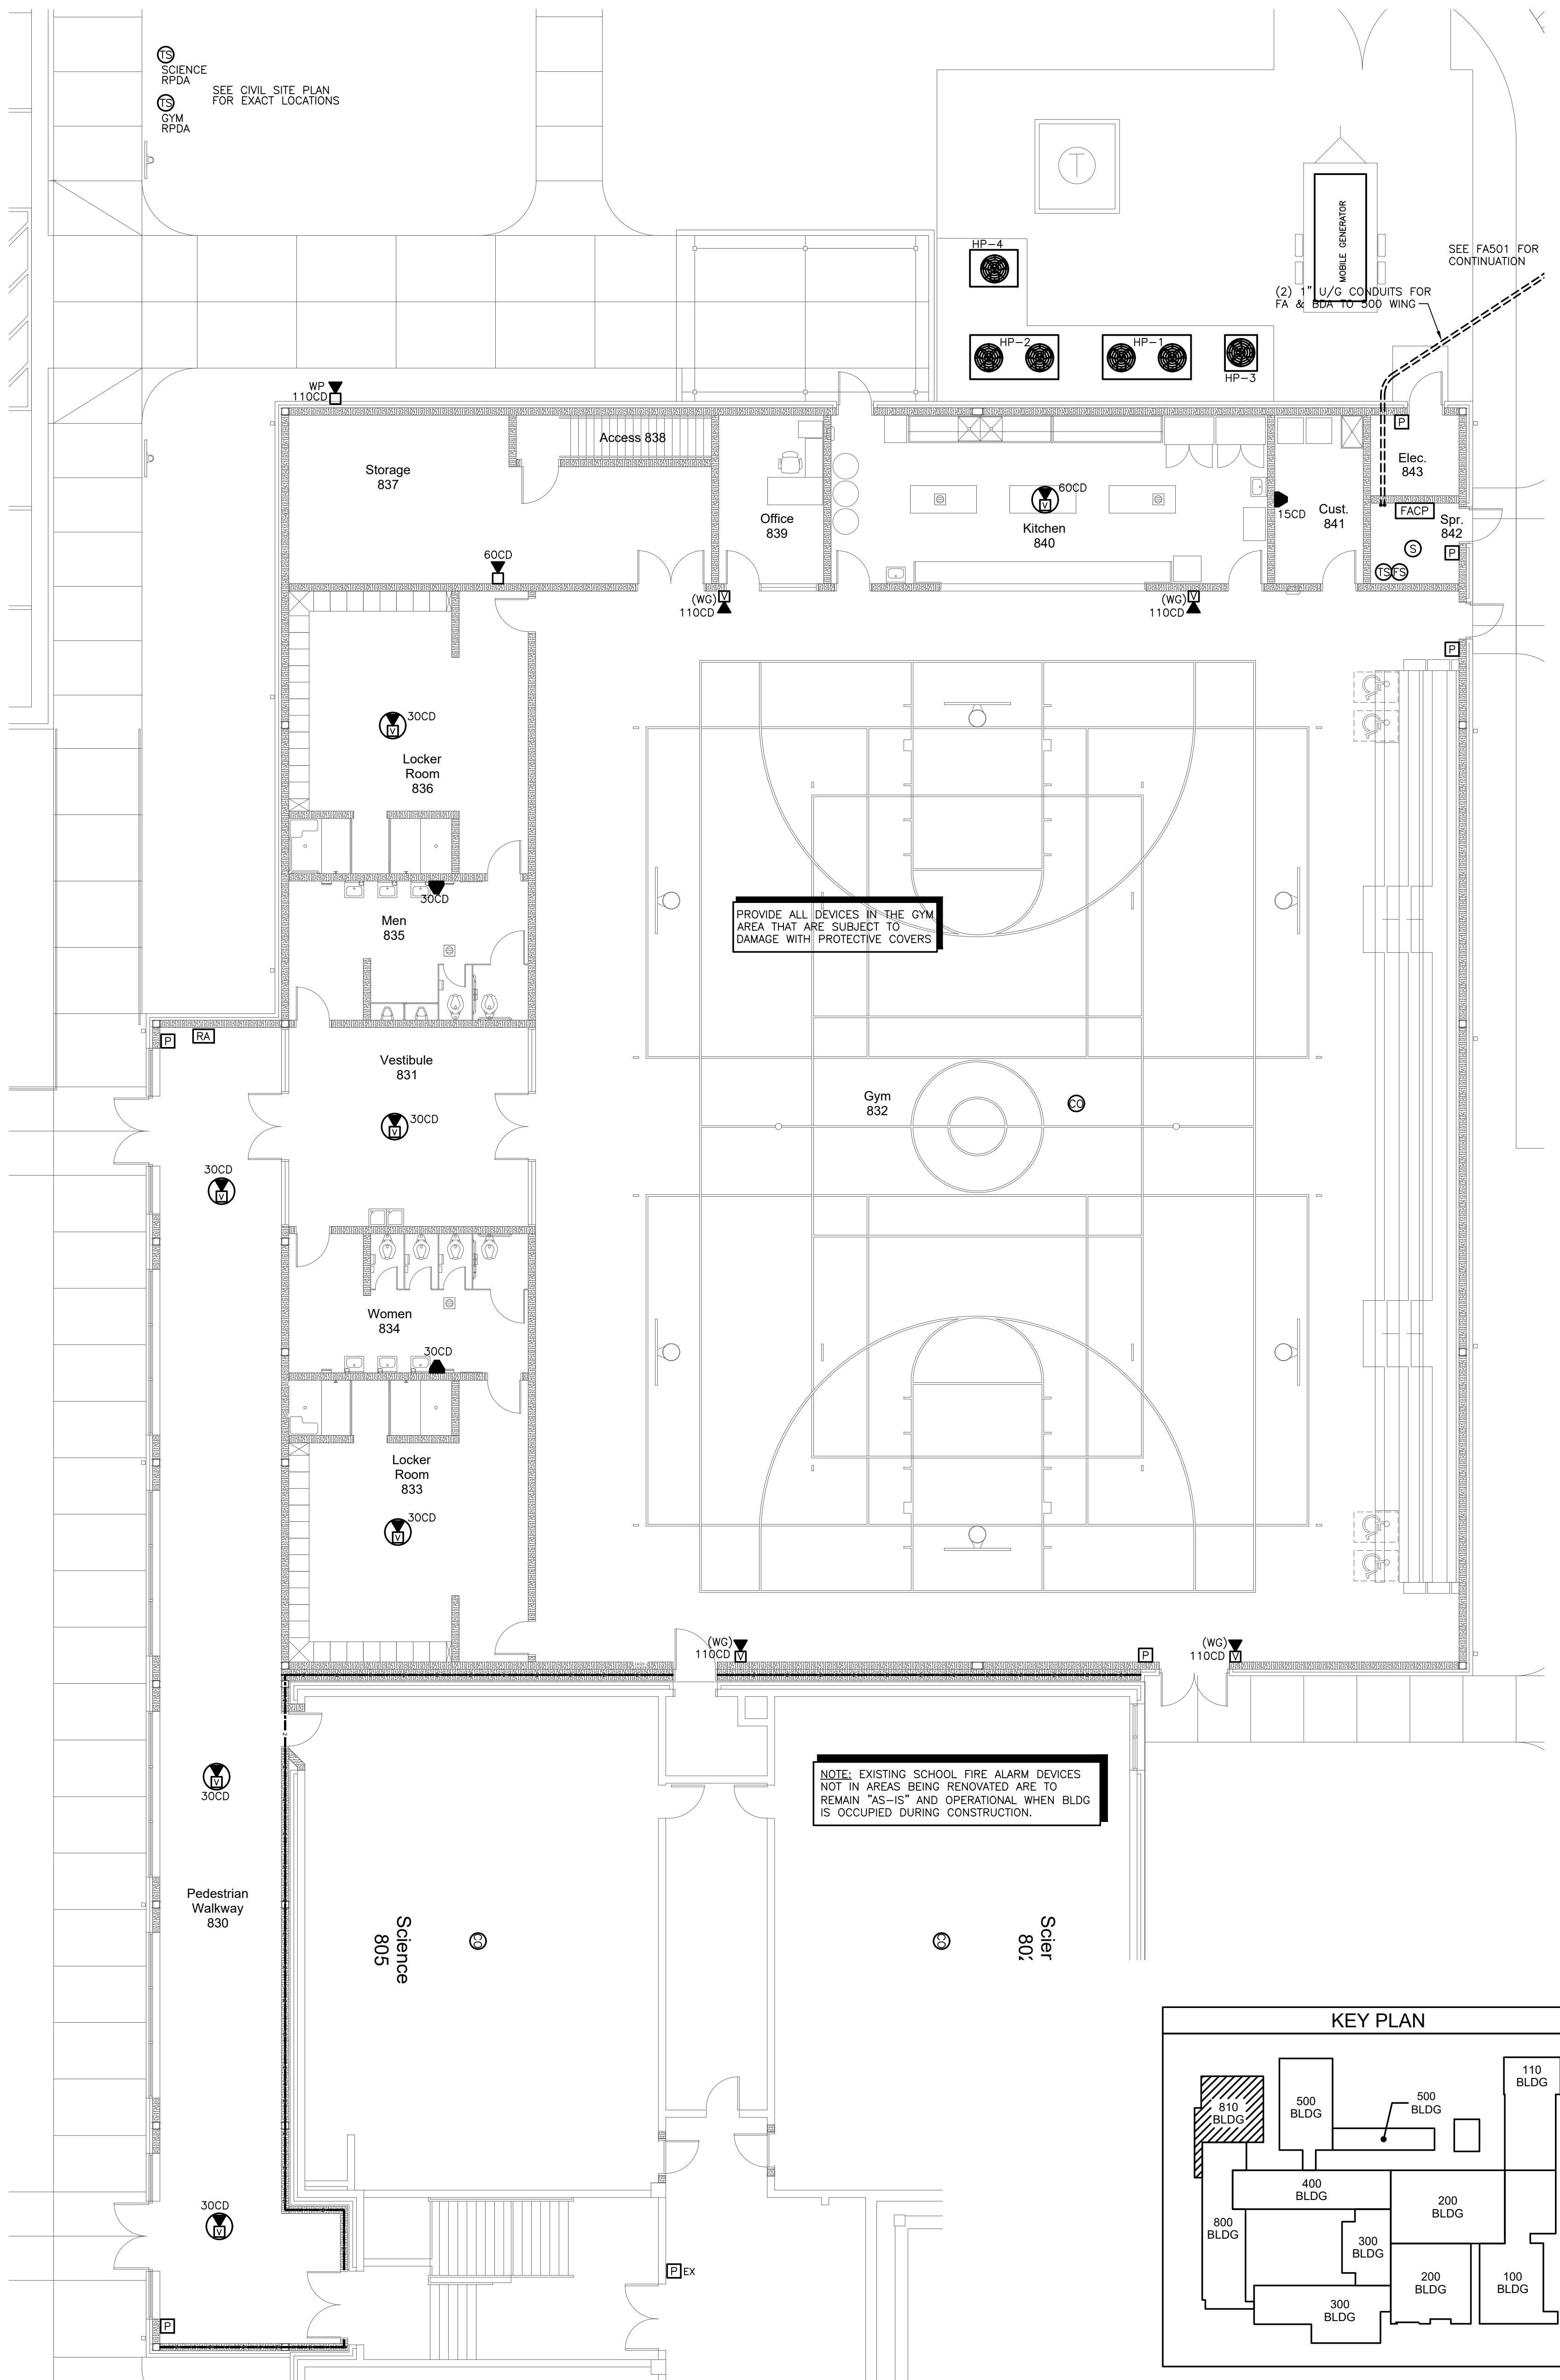

**811.1 ALT. BID - GYM FIRE ALARM PLAN**  
SCALE: 1/8" = 1'-0"

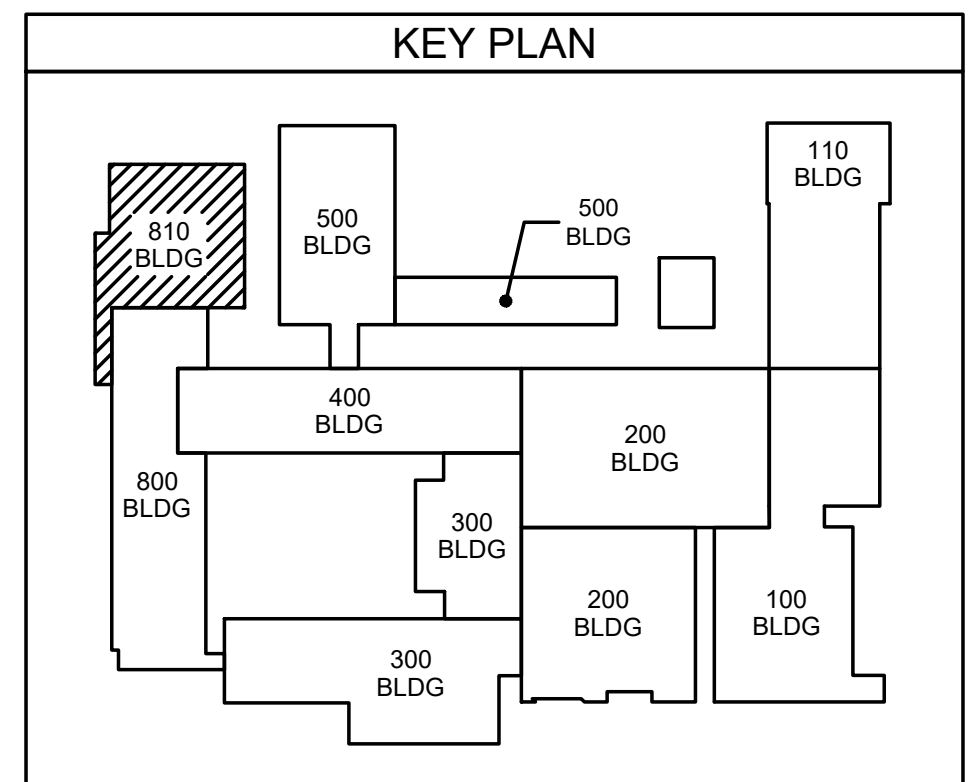


ES Project No: ES21080  
**ENGINEERING**  
 SOURCE OF NC, PA  
 102-42 Regency Blvd., Greenville, NC 27834  
 E-Mail Address: general@hiteengineering.com  
 Web (252) 428-0328 • Fax (252) 428-0462 • File #P-1073  
 11/27/23  
 D. Wilson P.E.  
 REGISTERED PROFESSIONAL ENGINEER  
 STATE OF NORTH CAROLINA  
 NUMBER 4178  
 EXPIRES 12/31/2024

THIS DRAWING IS THE PROPERTY OF ENGINEERING SOURCE OF NC, P.A. THIS DRAWING IS NOT TO BE COPIED IN WHOLE OR IN PART. THIS DRAWING OR THE INFORMATION HEREUPON IS NOT TO BE USED ON ANY OTHER PROJECT AND MUST BE RETURNED TO ENGINEERING SOURCE OF NC, P.A. UPON REQUEST. DO NOT SCALE THESE DRAWINGS. REFER TO ARCHITECTURAL DRAWINGS FOR EXACT DIMENSIONS.

No.	Date	Revision
1	11/09/23	ADDENDUM # 1
2	11/14/23	ADDENDUM # 2
3	11/21/23	ADDENDUM # 3
4	11/27/23	ADDENDUM # 4

**Hite associates**  
 ARCHITECTURE / PLANNING / TECHNOLOGY  
 2600 Meridian Drive / Greenville, NC 27834 / tel (252) 757-0333

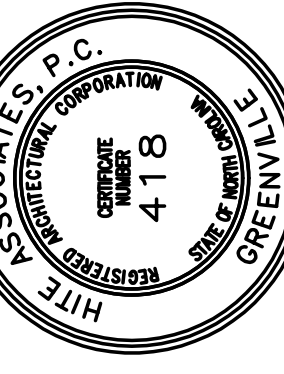

**New Additions & Renovations to**  
**West Carteret High School**  
 4700 Country Club Road, Morehead City, NC 28577  
 Carteret County Schools / North Carolina

Project No: 22112  
 Date: 03 Oct 2023  
 Drawing No: **FA 811**