


101.1 CAFETERIA AND KITCHEN MECHANICAL PLAN
SCALE: 1/8" = 1'-0"

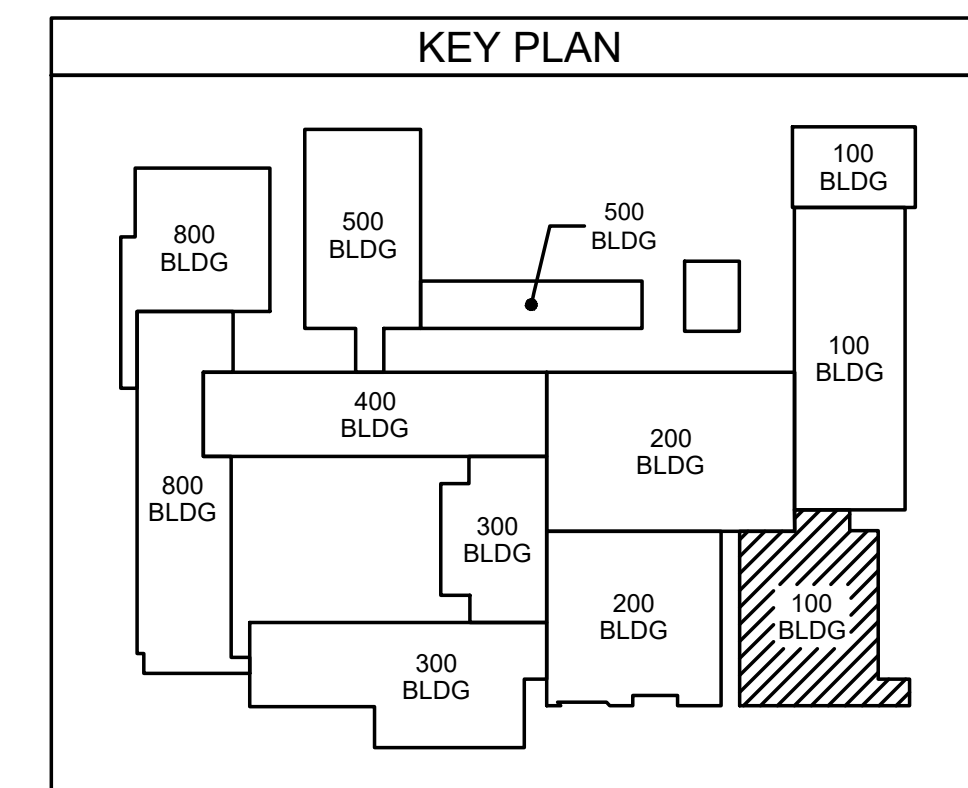

ENGINEERING
SOURCE OF NC, P.A.
102-42 Regency Blvd., Greensboro, NC 27334
E-Mail Address: general@hiteassociates.com
Tel (336) 432-3333 • Fax (336) 432-0462 • TDD (336) 432-0462

Hite Associates, P.C.
REGISTERED PROFESSIONAL ENGINEER
NUMBER 4178
GREENVILLE, SOUTH CAROLINA

Project No. 22112
Date: 03 Oct 2023
Drawing No. **M 101**

Hite associates
ARCHITECTURE / PLANNING / TECHNOLOGY
2600 Meridian Drive / Greenville, NC 27834 / Tel (252) 757-0333

No.	Date	Revision
1	11/17/23	ADDENDUM # 1
2	11/17/23	ADDENDUM # 2
3	11/21/23	ADDENDUM # 3
4	11/27/23	ADDENDUM # 4

Hite Associates, P.C.
REGISTERED PROFESSIONAL ENGINEER
NUMBER 4178
GREENVILLE, SOUTH CAROLINA

New Additions & Renovations to West Carteret High School
4700 Country Club Road, Morehead City, NC 28577
Carteret County Schools / North Carolina

THIS DRAWING IS THE PROPERTY OF ENGINEERING SOURCE OF NC, P.A. THIS DRAWING IS NOT TO BE COPIED IN WHOLE OR IN PART. THIS DRAWING OR THE INFORMATION HEREON IS NOT TO BE USED ON ANY OTHER PROJECT AND MUST BE RETURNED TO ENGINEERING SOURCE OF NC, P.A. UPON REQUEST. DO NOT SCALE THESE DRAWINGS. REFER TO ARCHITECTURAL DRAWINGS FOR EXACT DIMENSIONS.