


NOTE: ALL EXISTING THERMOSTATS AND HUMIDISTATS ARE TO REMAIN. MECHANICAL/CONTROLS CONTRACTOR SHALL CONNECT NEW HVAC UNITS BACK TO EXISTING THERMOSTATS AND HUMIDISTATS. ALL NEW THERMOSTATS INDICATED ON PLANS SHALL BE COMBINATION THERMOSTAT AND HUMIDISTAT DEVICES.

100 CLASSROOM BUILDING
111.1 MECHANICAL PLAN
 SCALE: 1/8" = 1'-0"

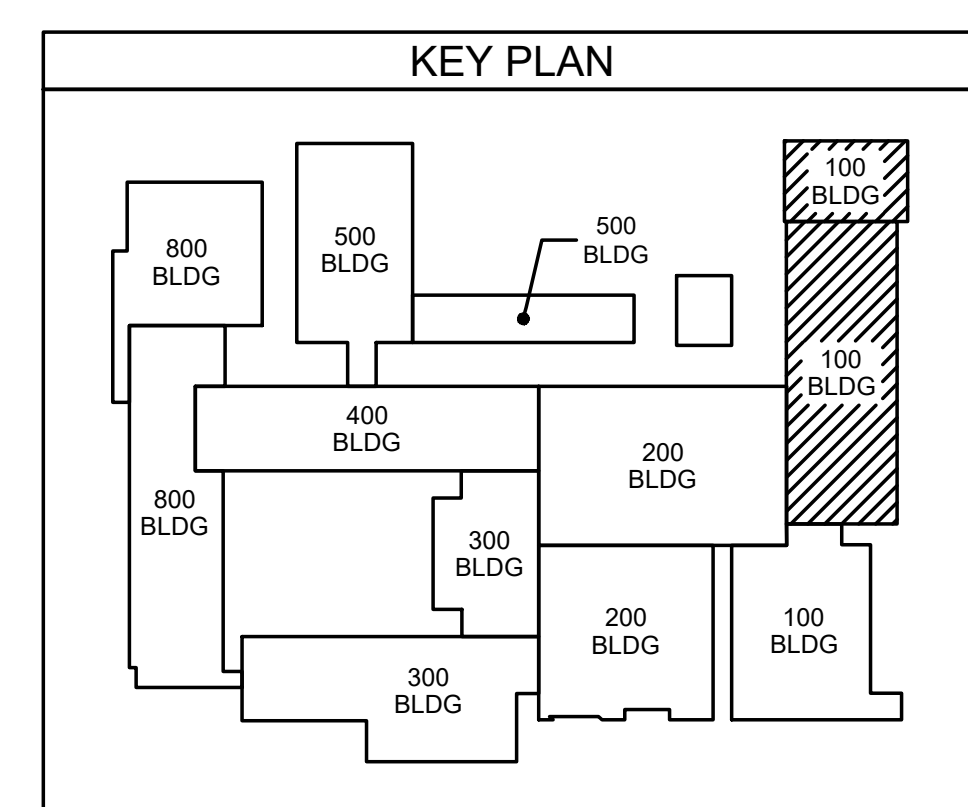

ENGINEERING
 SOURCE OF NC, PA.

ES21060


100-40 Regency Blvd, Greensboro, NC 27834
 E-Mail Address: general@engsource.com
 Tel: (336) 438-0338 • Fax: (336) 438-0462 • TDD: (336) 438-1103

121/123

No.	Date	Revision
1	12/01/23	ADDENDUM # 6
2	11/27/23	ADDENDUM # 4
3	11/27/23	ADDENDUM # 3
4	11/27/23	ADDENDUM # 2
5	11/27/23	ADDENDUM # 1

Hite associates
 ARCHITECTURE / PLANNING / TECHNOLOGY

2800 Meridian Drive / Greensboro, NC 27834 / Tel: (252) 757-0333

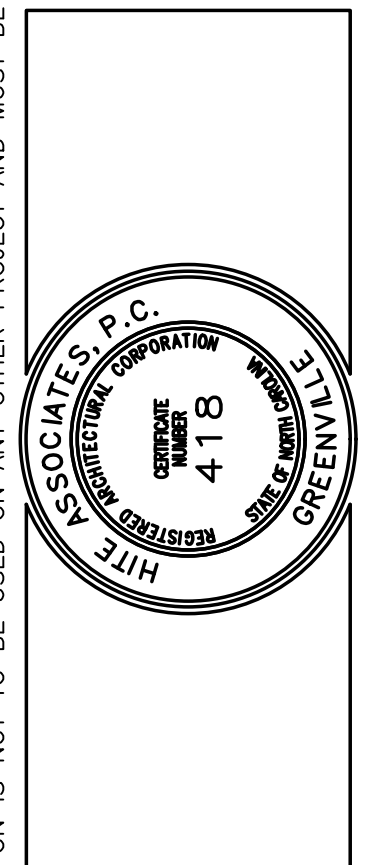

New Additions & Renovations to
West Carteret High School
 4700 Country Club Road, Morehead City NC 28577
 Carteret County Schools / North Carolina

Project No. 22112
 Date: 03 Oct 2023
 Drawing no. **M 111**

THIS DRAWING IS THE PROPERTY OF ENGINEERING SOURCE OF NC, P.A. THIS DRAWING IS NOT TO BE COPIED IN WHOLE OR IN PART. THIS DRAWING OR THE INFORMATION HEREUPON IS NOT TO BE USED ON ANY OTHER PROJECT AND MUST BE RETURNED TO ENGINEERING SOURCE OF NC, P.A. UPON REQUEST. DO NOT SCALE THESE DRAWINGS. REFER TO ARCHITECTURAL DRAWINGS FOR EXACT DIMENSIONS.