


201.1 GYM AND LOCKER ROOM  
MECHANICAL PLAN  
SCALE: 1/8" = 1'-0"

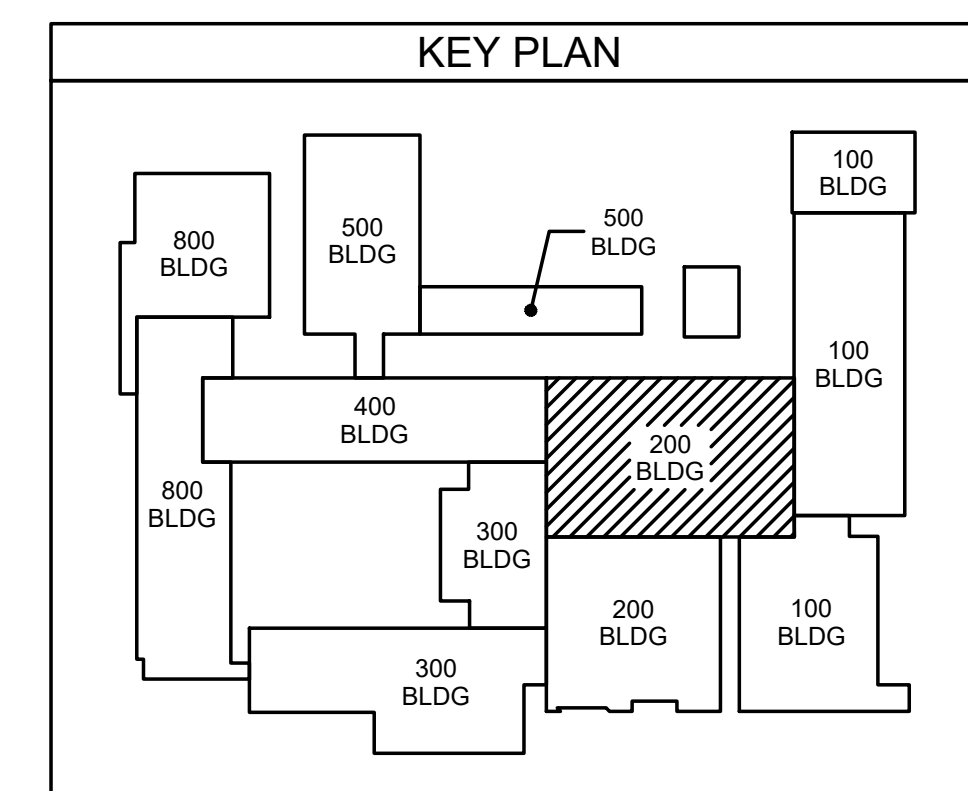

ES Project No. ES21080

ENGINEERING SOURCE OF NC, P.A.


102-42 Regency Blvd. Greensboro, NC 27434  
E-Mail Address: general@hiteassociates.com  
Web (252) 432-0328 • Fax (252) 432-0462 • Telex PC-1073

11/27/23

STATE OF NORTH CAROLINA  
J. Hite, P.E.  
Professional Engineer  
No. 11173

No.	Date	Revision
4	11/27/23	ADDENDUM # 4
3	11/21/23	ADDENDUM # 3
2	11/14/23	ADDENDUM # 2
1	11/09/23	ADDENDUM # 1

**Hite associates**  
ARCHITECTURE / PLANNING / TECHNOLOGY  
2600 Meridian Drive / Greenville, NC 27834 / tel (252) 757-0333

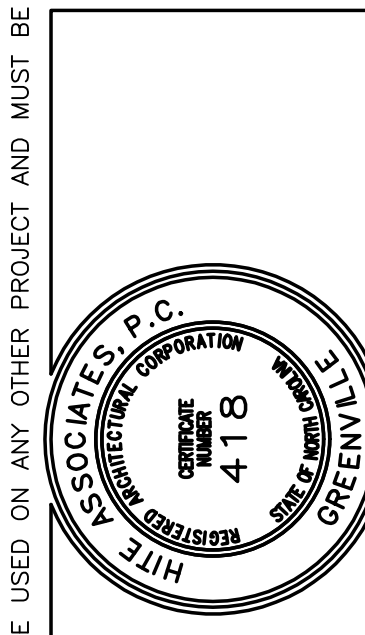

New Additions & Renovations to  
**West Carteret High School**  
4700 Country Club Road, Morehead City, NC 28577  
Carteret County Schools / North Carolina

Project No. 22112  
Date: 03 Oct 2023  
Drawing No. **M 201**

THIS DRAWING IS THE PROPERTY OF ENGINEERING SOURCE OF NC, P.A. THIS DRAWING IS NOT TO BE COPIED IN WHOLE OR IN PART. THIS DRAWING OR THE INFORMATION HEREON IS NOT TO BE USED ON ANY OTHER PROJECT AND MUST BE RETURNED TO ENGINEERING SOURCE OF NC, P.A. UPON REQUEST. DO NOT SCALE THESE DRAWINGS. REFER TO ARCHITECTURAL DRAWINGS FOR EXACT DIMENSIONS.