


201.1 GYM AND LOCKER ROOM MECHANICAL PLAN
SCALE: 1/8" = 1'-0"

NOTE: ALL EXISTING THERMOSTATS AND HUMIDISTATS ARE TO REMAIN. MECHANICAL/CONTROLS CONTRACTOR SHALL CONNECT NEW HVAC UNITS BACK TO EXISTING THERMOSTATS AND HUMIDISTATS. ALL NEW THERMOSTATS INDICATED ON PLANS SHALL BE COMBINATION THERMOSTAT AND HUMIDISTAT DEVICES.

NOTE: EXISTING CHILLED WATER MAIN PIPING SHALL REMAIN OPERATIONAL UNTIL NEW CHILLED WATER MAINS ARE INSTALLED AND ALL EXISTING AND NEW CHILLED WATER BRANCH LINES ARE CONNECTED TO NEW CHILLED WATER PIPING MAINS. EXISTING CHILLED WATER MAIN PIPING SHALL BE DEMOLISHED BY MECHANICAL CONTRACTOR ONCE NEW CHILLED WATER MAINS ARE CONNECTED AND OPERATIONAL.


NOTE: ALL EXISTING BRANCH HYDRONIC PIPING FROM EXISTING HVAC UNITS TO MAIN PIPES ARE EXISTING TO REMAIN. MECHANICAL CONTRACTOR SHALL DISCONNECT EXISTING HVAC UNIT INDICATED TO BE REPLACED AND CONNECT NEW HVAC UNIT BACK TO EXISTING HYDRONIC BRANCH PIPING. MECHANICAL CONTRACTOR SHALL ANTICIPATE SMALL ADJUSTMENTS TO EXISTING HYDRONIC BRANCH PIPING AND PROVIDE ANY MATERIAL, FITTINGS, AND LABOR NECESSARY TO MAKE FINAL CONNECTIONS.

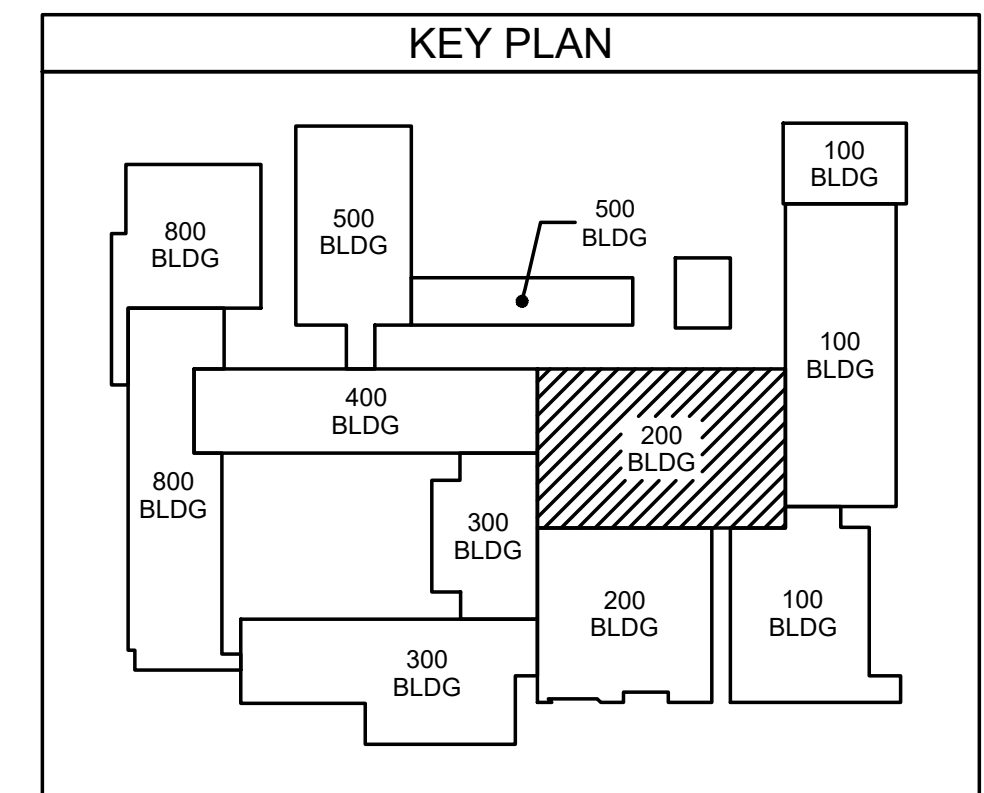

ENGINEERING
SOURCE OF NC, P.A.
100-40 Regency Blvd. Greensboro, NC 27434
E-Mail Address: generalm@engsource.com
Tel: (336) 438-0338 • Fax: (336) 438-0462 • Item # E-103

No.	Date	Revision
1	12/01/23	ADDENDUM # 6
2	11/27/23	ADDENDUM # 4
3	11/27/23	ADDENDUM # 3
4	11/27/23	ADDENDUM # 2
5	11/27/23	ADDENDUM # 1

Hite associates
ARCHITECTURE / PLANNING / TECHNOLOGY
2600 Meridian Drive / Greenville, NC 27834 / Tel: (252) 757-0333

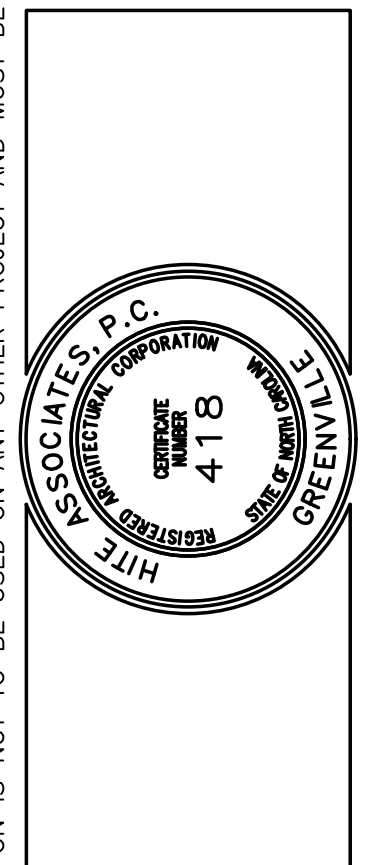

New Additions & Renovations to
West Carteret High School
4700 Country Club Road, Morehead City NC 28577
Carteret County Schools / North Carolina

Project No. 22112
Date: 03 Oct 2023
Drawing No. **M 201**

THIS DRAWING IS THE PROPERTY OF ENGINEERING SOURCE OF NC, P.A. THIS DRAWING IS NOT TO BE COPIED IN WHOLE OR IN PART. THIS DRAWING OR THE INFORMATION HEREON IS NOT TO BE USED ON ANY OTHER PROJECT AND MUST BE RETURNED TO ENGINEERING SOURCE OF NC, P.A. UPON REQUEST. DO NOT SCALE THESE DRAWINGS. REFER TO ARCHITECTURAL DRAWINGS FOR EXACT DIMENSIONS.