



600 CLASSROOM WING (SECOND FLOOR)
401.2 MECHANICAL PLAN
 SCALE: 1/8" = 1'-0"

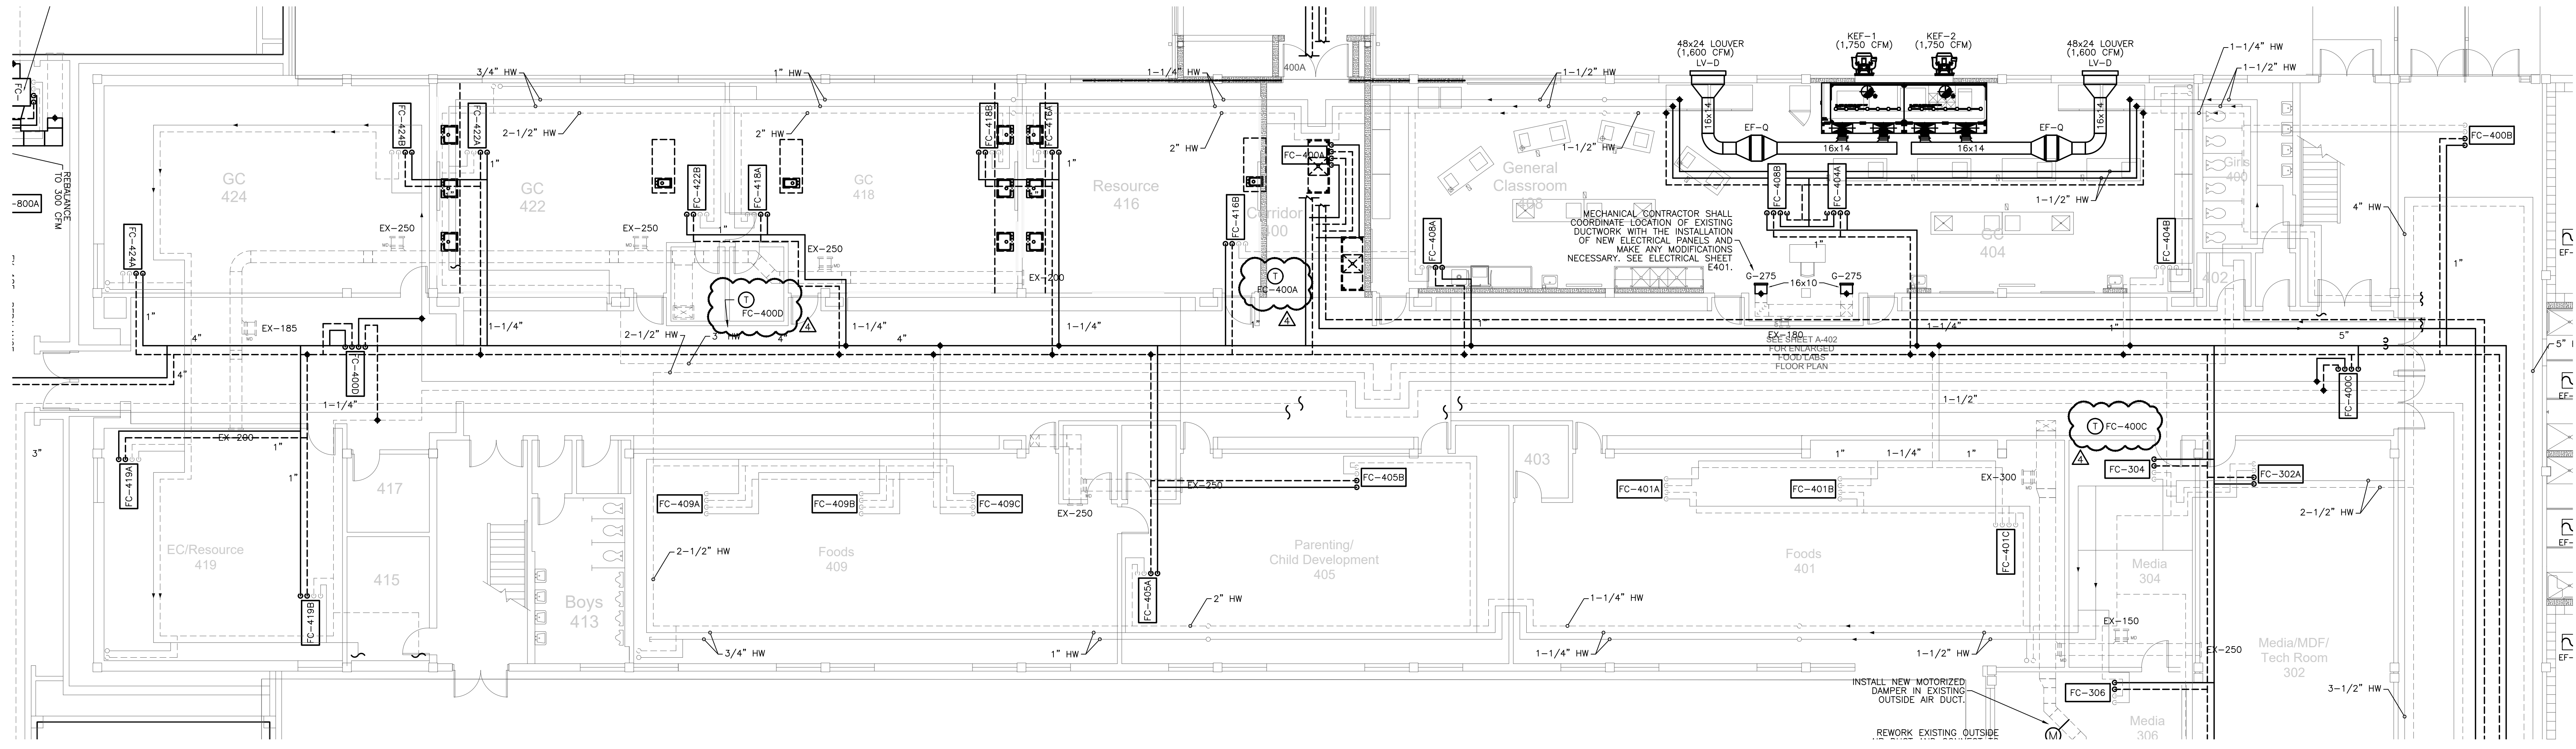

400 CLASSROOM WING (FIRST FLOOR)
401.1 MECHANICAL PLAN
 SCALE: 1/8" = 1'-0"

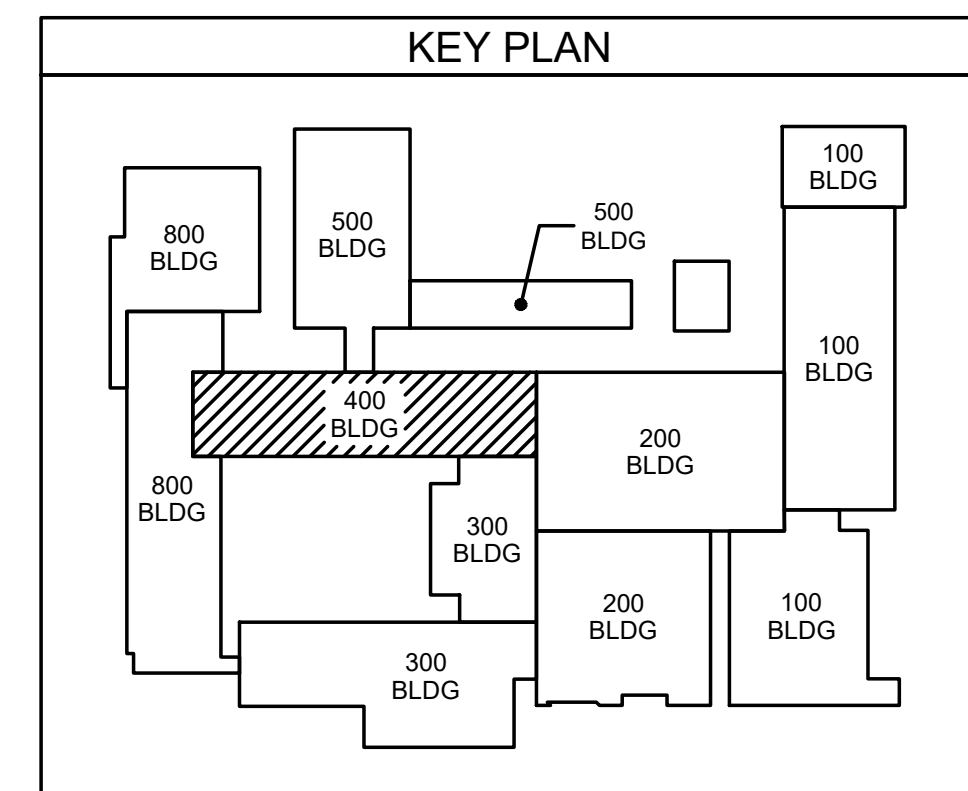

ES Project No. ES21080
 102-42 Reptony Blvd., Greenville, NC 27834
 E-Mail Address: general@hiteassociates.com
 Web (919) 438-0338 • Fax (919) 438-0462 • Telex FC-1973


ENGINEERING
 SOURCE OF NC, P.A.

D. Wilson
 11/27/23
 WILSON

THIS DRAWING IS THE PROPERTY OF ENGINEERING SOURCE OF NC, P.A. THIS DRAWING IS NOT TO BE COPIED IN WHOLE OR IN PART. THIS DRAWING OR THE INFORMATION HEREON IS NOT TO BE USED ON ANY OTHER PROJECT AND MUST BE RETURNED TO ENGINEERING SOURCE OF NC, P.A. UPON REQUEST. DO NOT SCALE THESE DRAWINGS. REFER TO ARCHITECTURAL DRAWINGS FOR EXACT DIMENSIONS.

No.	Date	Revision
1	11/17/23	ADDENDUM # 1
2	11/17/23	ADDENDUM # 2
3	11/21/23	ADDENDUM # 3
4	11/27/23	ADDENDUM # 4

Hite associates
 ARCHITECTURE / PLANNING / TECHNOLOGY
 2600 Meridian Drive / Greenville, NC 27834 / tel (252) 757-0333

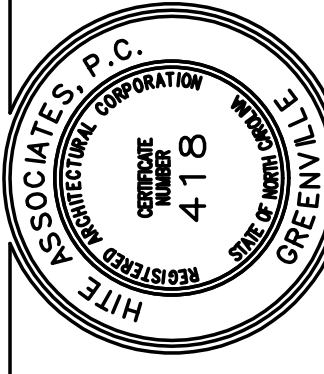

New Additions & Renovations to
West Carteret High School
 4700 Country Club Road, Morehead City, NC 28577
 Carteret County Schools / North Carolina

Project No. 22112
 Date: 03 Oct 2023
 Drawing No. **M 401**