




500 CLASSROOM WING  
**501.2 MECHANICAL PLATFORM PLAN**  
 SCALE: 1/8" = 1'-0"

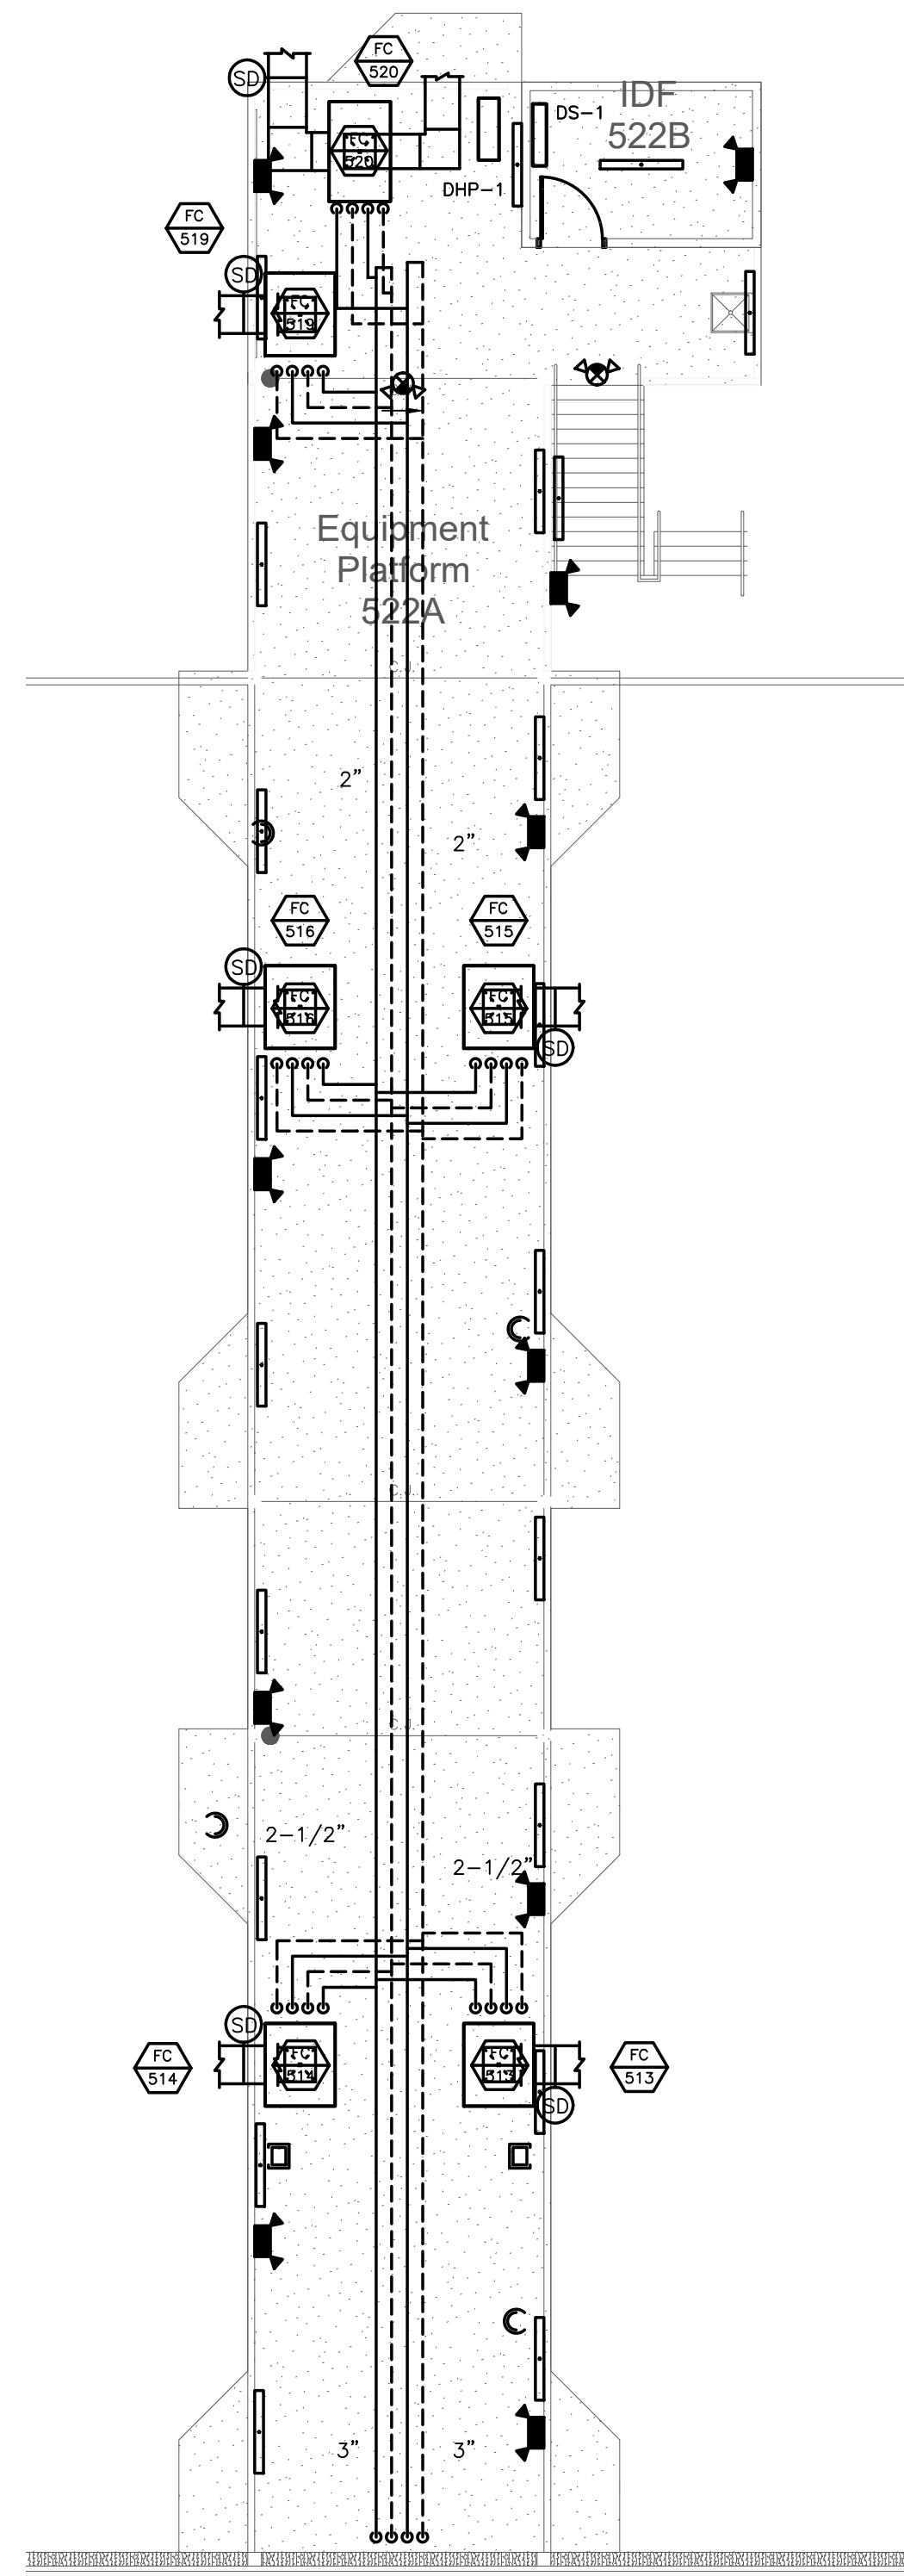

500 CLASSROOM WING  
**501.2 MECHANICAL PIPING PLAN**  
 SCALE: 1/8" = 1'-0"

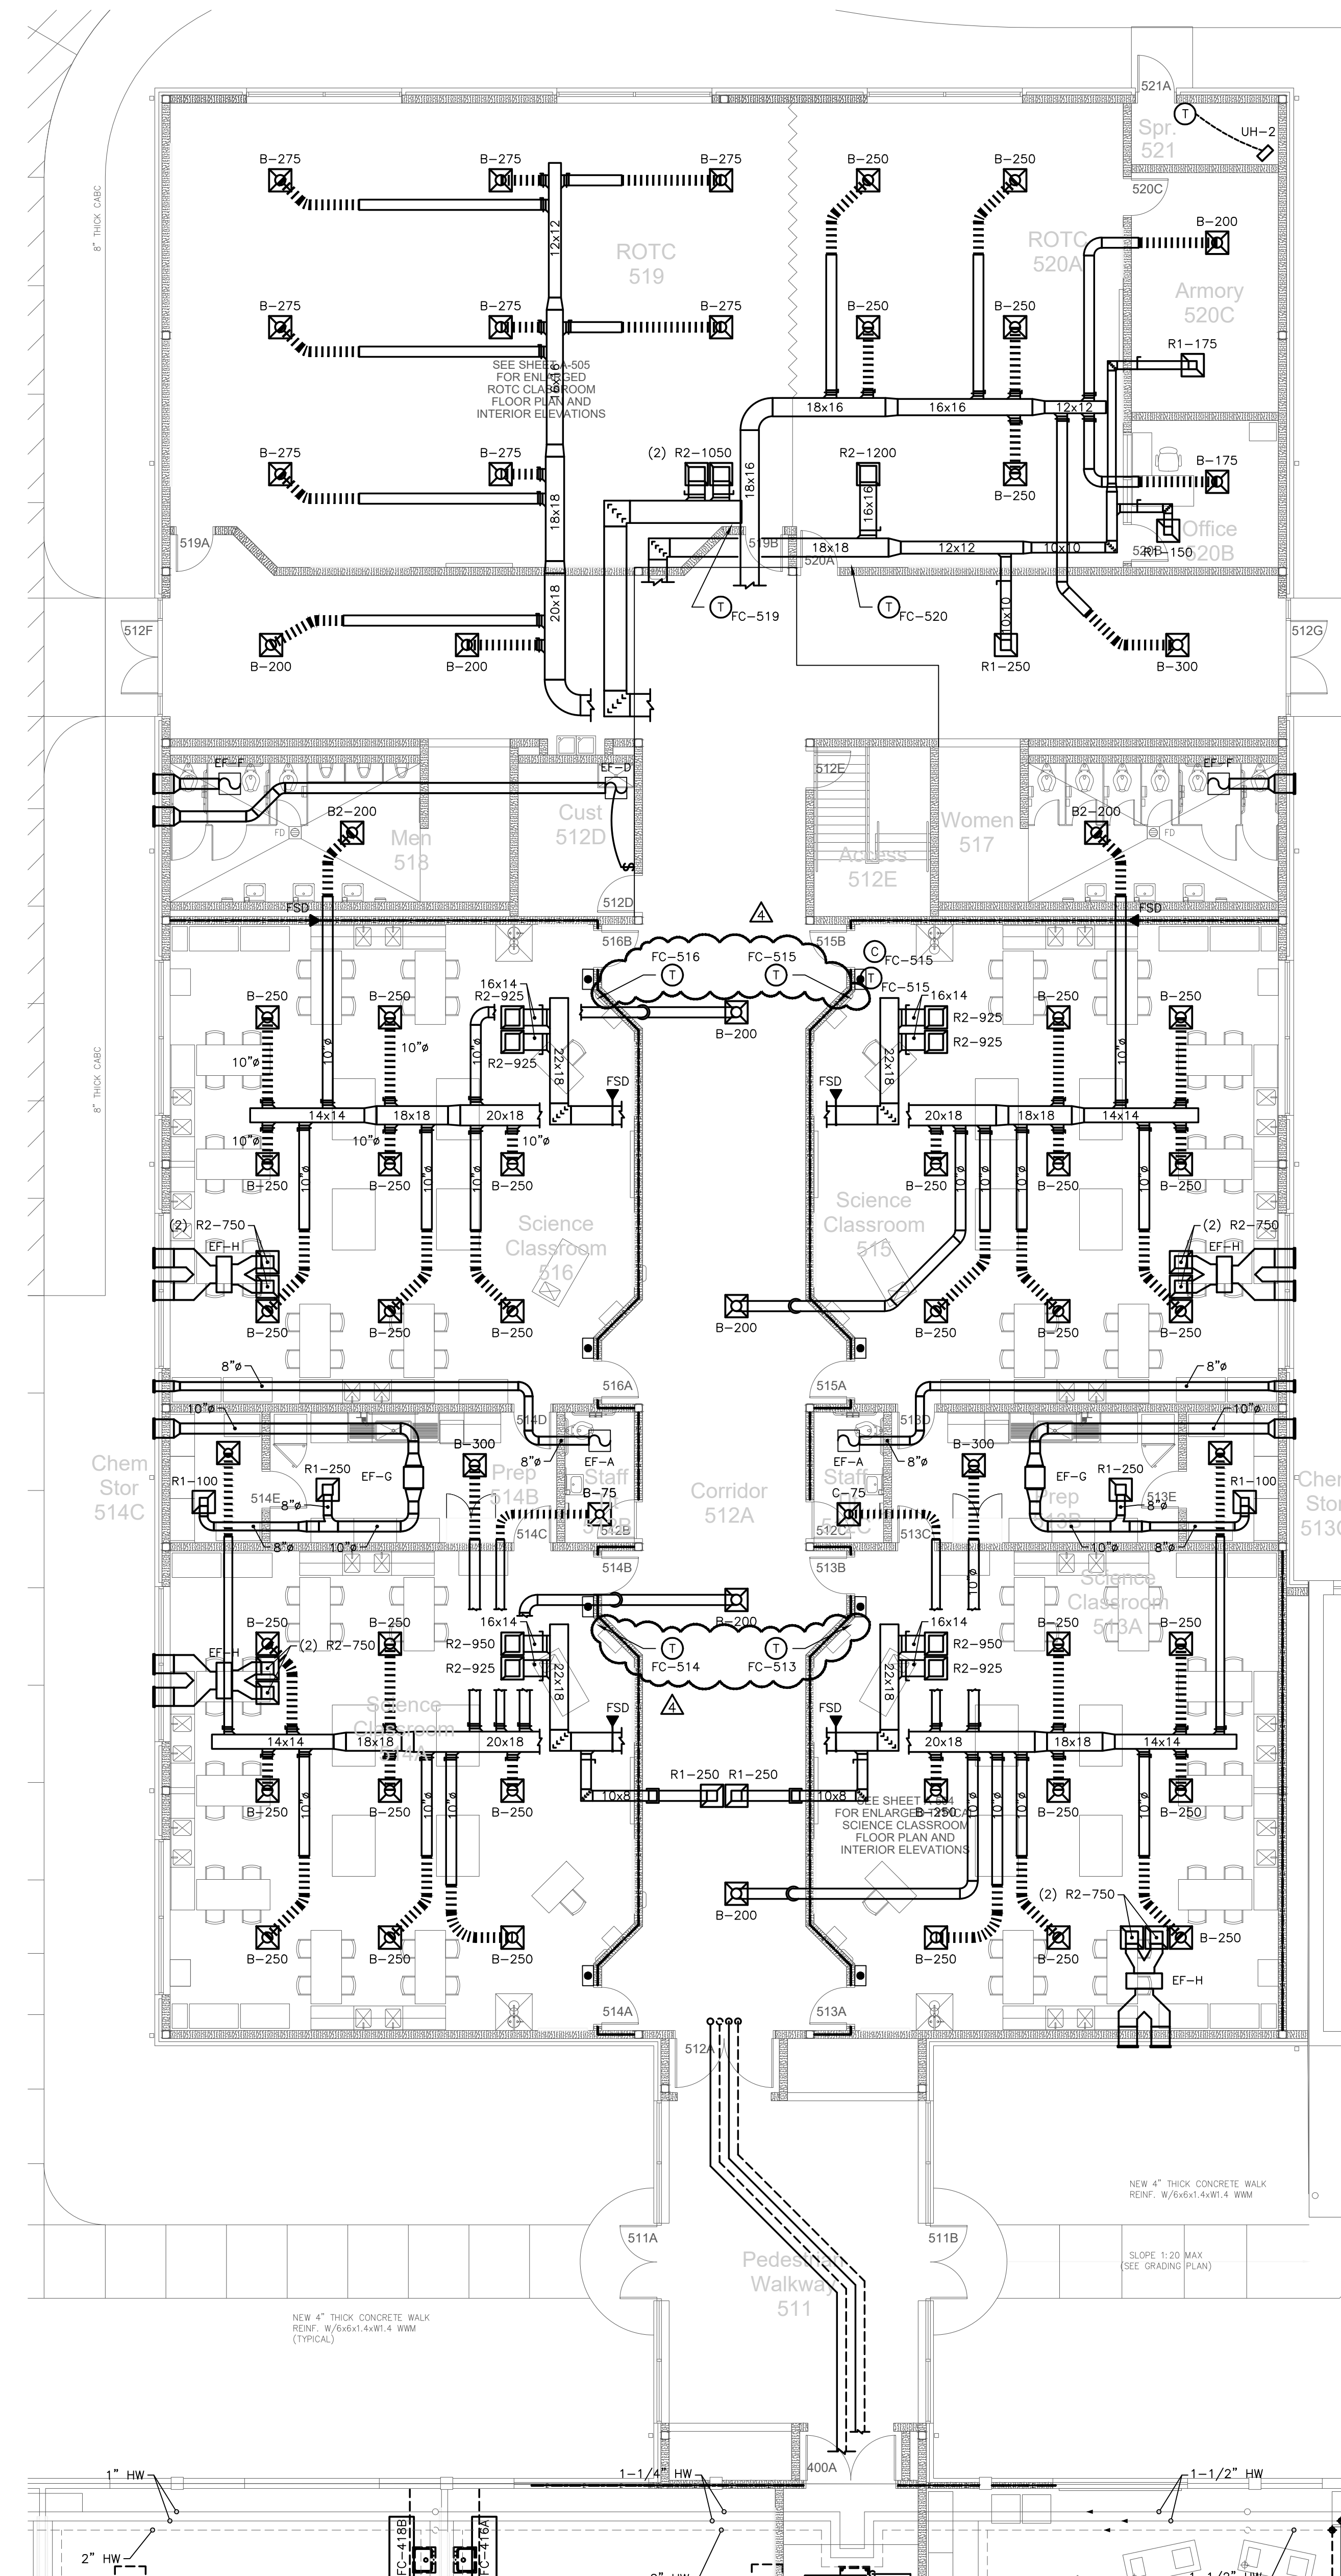

500 CLASSROOM WING  
**501.1 MECHANICAL PLAN**  
 SCALE: 1/8" = 1'-0"

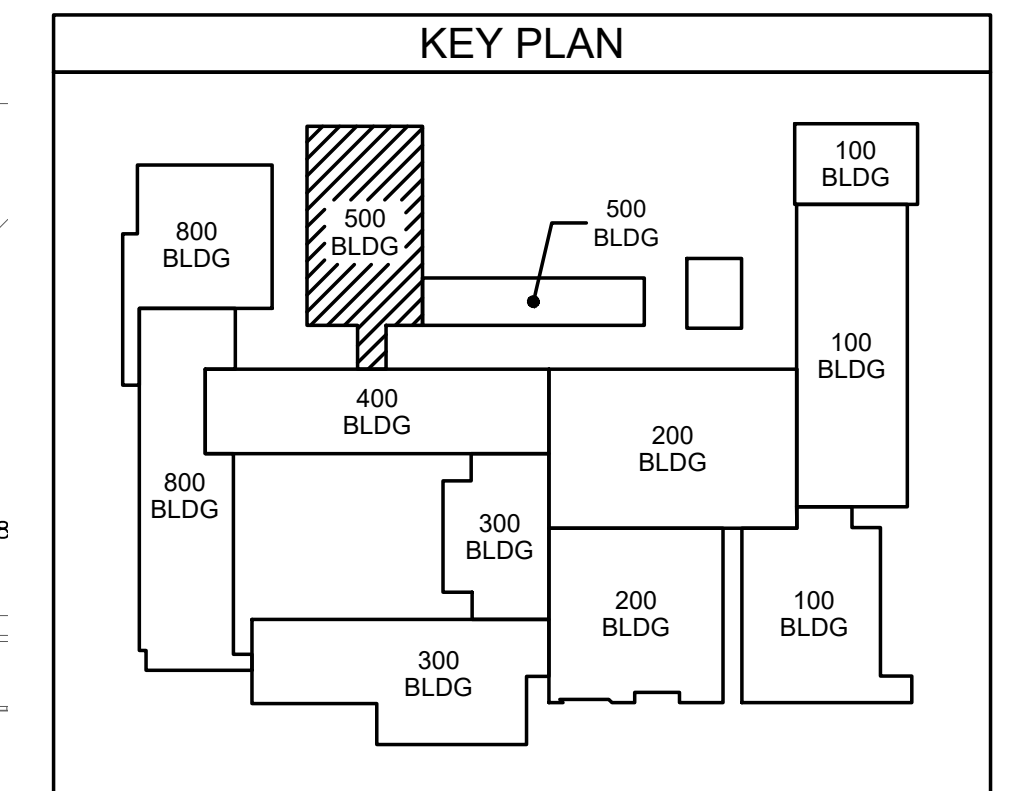


**ENGINEERING**  
 SOURCE OF NC, PA.

**ES21080**  
 Project No. ES21080  
 102-42 Rapunzel Blvd., Greenville, NC 27834  
 E-Mail Address: general@hiteassociates.com  
 Web (252) 432-0333 • Fax (252) 432-0462 • Telex R-1973

**D. Hite**  
 11/27/23  
 HITE ASSOCIATES, P.C.  
 WILSON FOU

No.	Date	Revision
4	11/27/23	ADDENDUM # 4
3	11/17/23	ADDENDUM # 3
2	11/17/23	ADDENDUM # 2
1	11/09/23	ADDENDUM # 1

**Hite associates**  
 ARCHITECTURE / PLANNING / TECHNOLOGY  
 2600 Meridian Drive / Greenville, NC 27834 / Tel (252) 757-0333

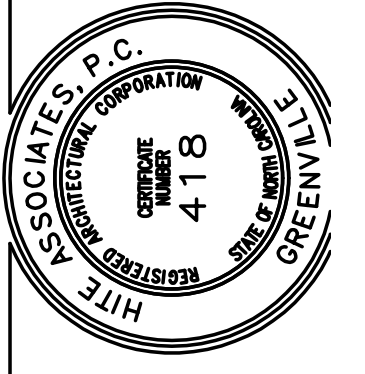

New Additions & Renovations to  
**West Carteret High School**  
 4700 Country Club Road, Morehead City, NC 28577  
 Carteret County Schools / North Carolina

Project No. 22112  
 Date: 03 Oct 2023  
 Drawing No. **M 501**

THIS DRAWING IS THE PROPERTY OF ENGINEERING SOURCE OF NC, P.A. THIS DRAWING IS NOT TO BE COPIED IN WHOLE OR IN PART. THIS DRAWING OR THE INFORMATION HEREON IS NOT TO BE USED ON ANY OTHER PROJECT AND MUST BE RETURNED TO ENGINEERING SOURCE OF NC, P.A. UPON REQUEST. DO NOT SCALE THESE DRAWINGS. REFER TO ARCHITECTURAL DRAWINGS FOR EXACT DIMENSIONS.