



**501.2** 500 CLASSROOM WING  
MECHANICAL PLATFORM PLAN  
SCALE: 1/8" = 1'-0"

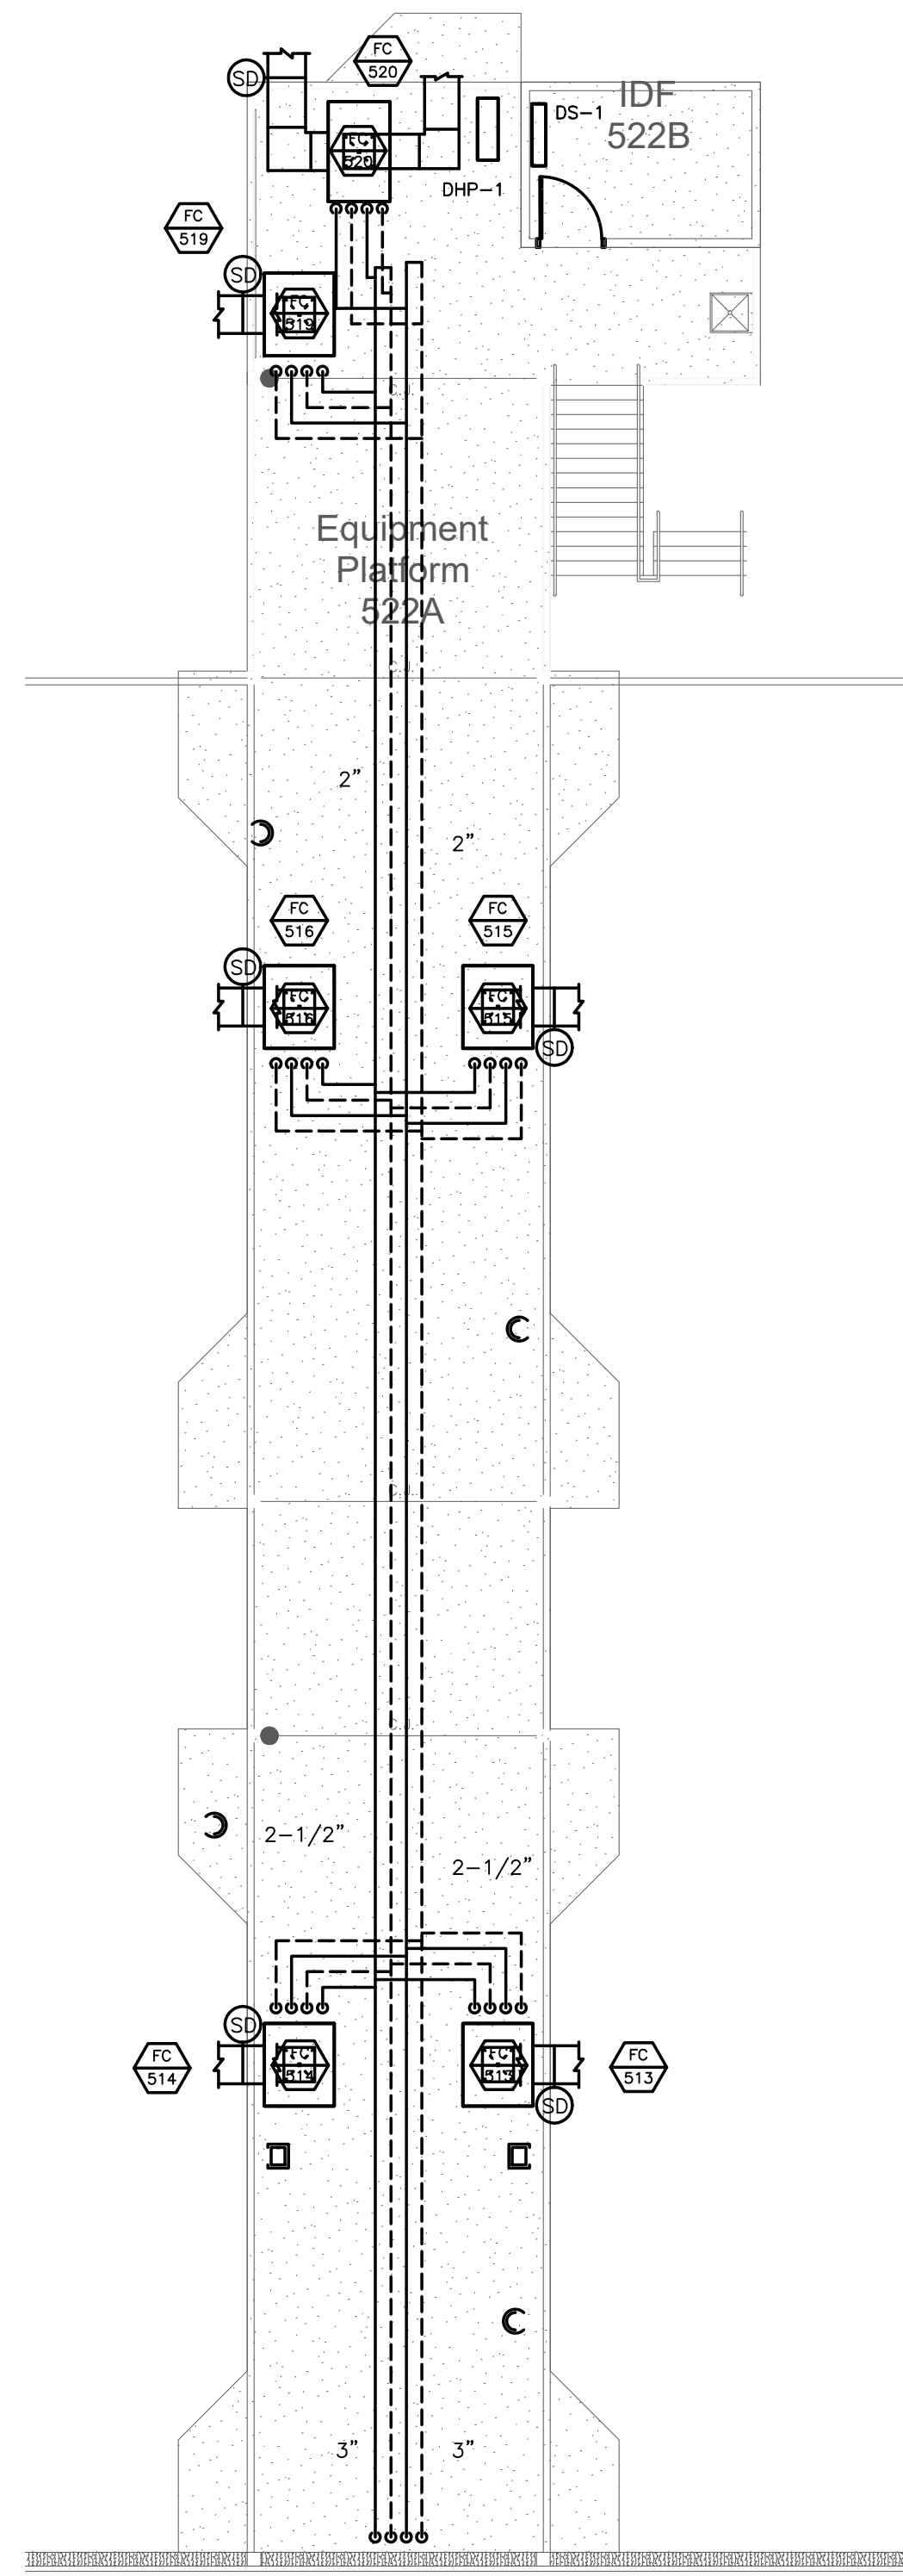


**501.2** 500 CLASSROOM WING  
MECHANICAL PIPING PLAN  
SCALE: 1/8" = 1'-0"

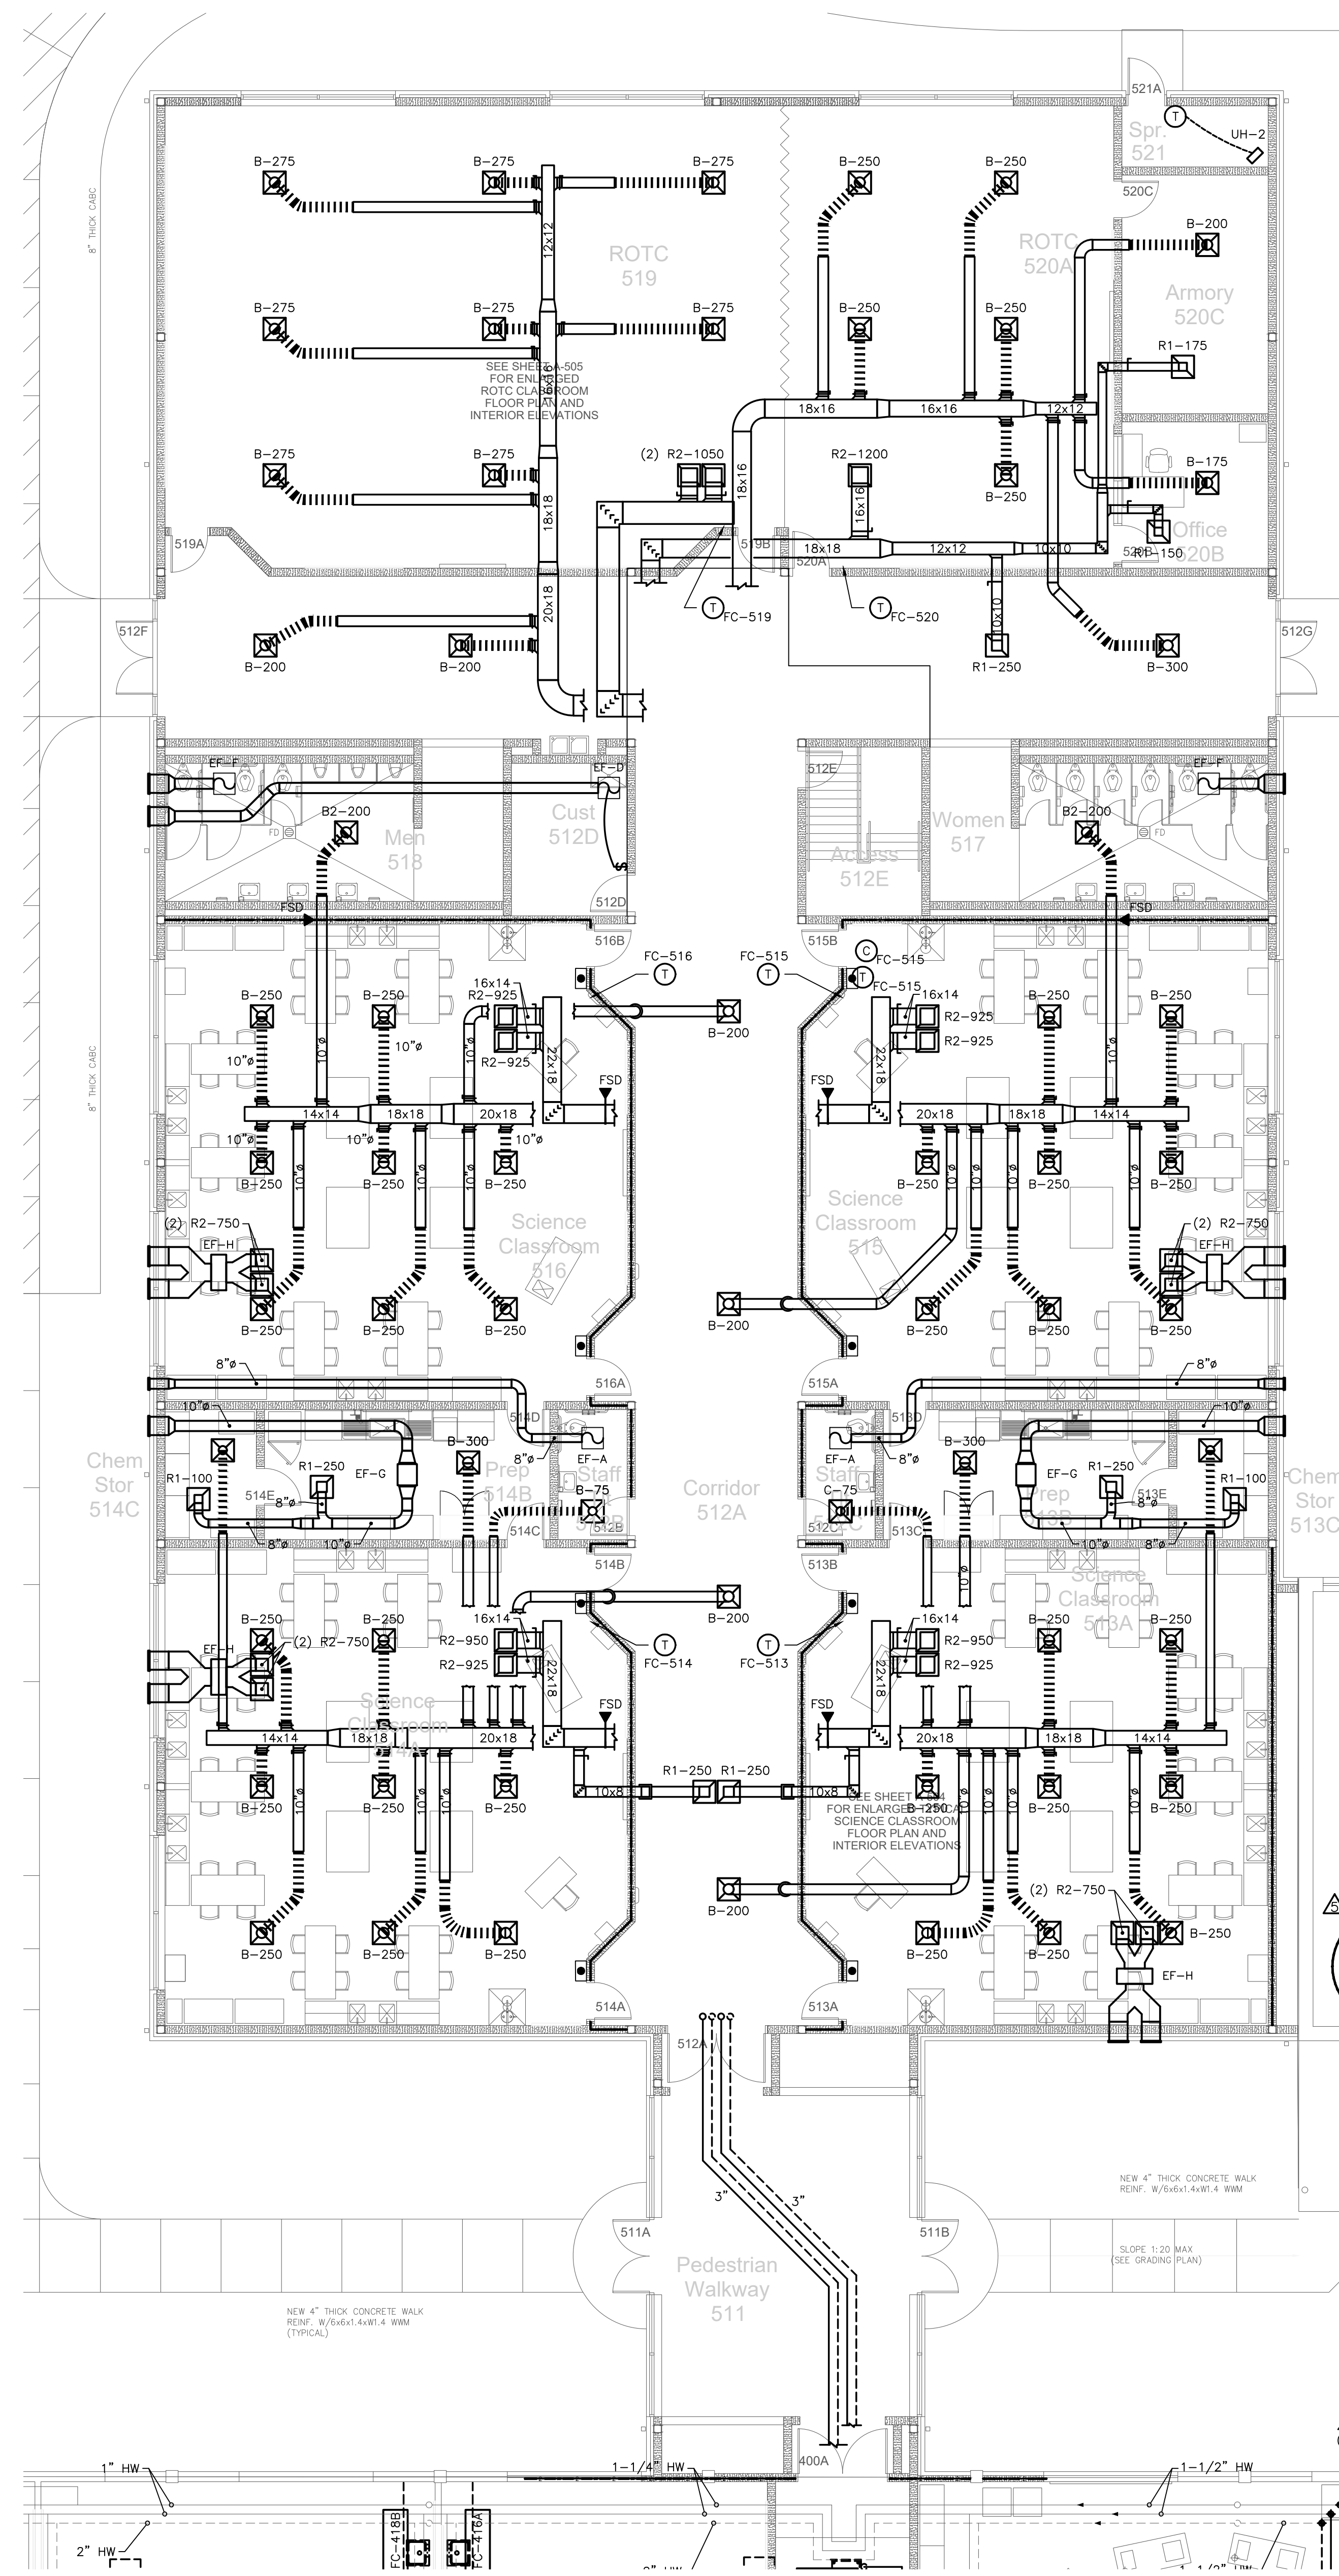

**501.1** 500 CLASSROOM WING  
MECHANICAL PLAN  
SCALE: 1/8" = 1'-0"

NOTE: ALL NEW THERMOSTATS INDICATED ON PLANS SHALL BE COMBINATION THERMOSTAT AND HUMIDISTAT DEVICES.

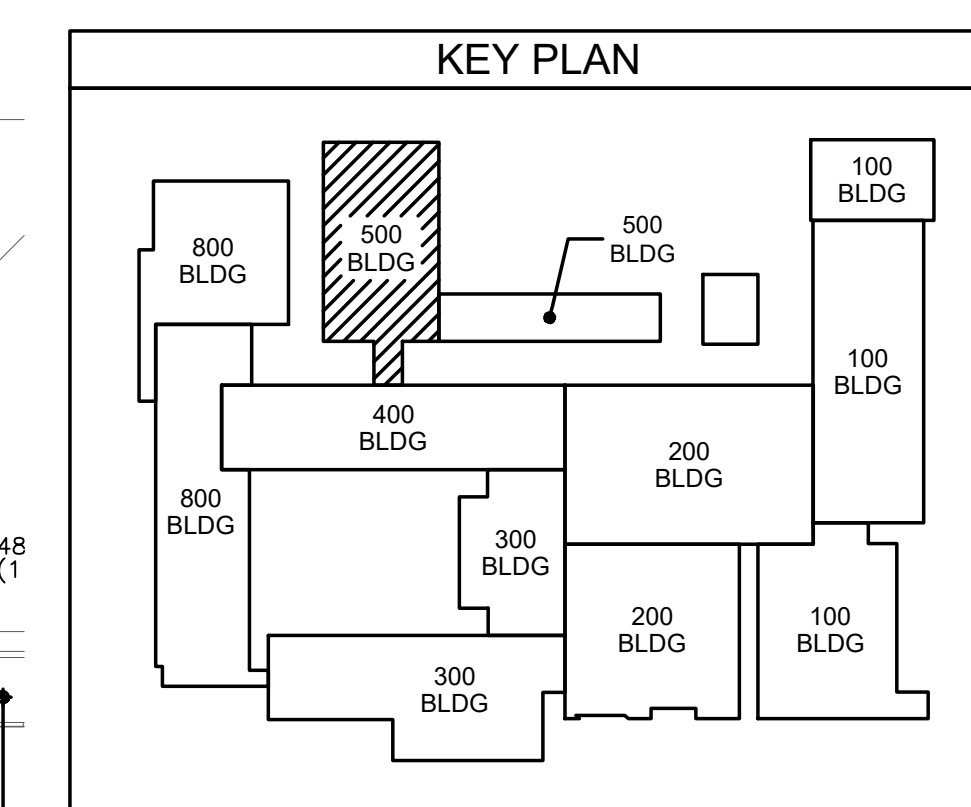


**ENGINEERING**  
SOURCE OF NC, P.A.  
100-40 Regency Blvd. Greensboro, NC 27434  
E-Mail Address: general@engsource.com  
Tel: (336) 439-0338 • Fax: (336) 439-0462 • TDD: (336) 439-1073

**ENGINEERING**  
12/1/23

No.	Date	Revision
1	12/01/23	ADDENDUM # 6
2	11/27/23	ADDENDUM # 4
3	11/27/23	ADDENDUM # 3
4	11/17/23	ADDENDUM # 2
5	11/09/23	ADDENDUM # 1

**Hite associates**  
ARCHITECTURE / PLANNING / TECHNOLOGY  
2800 Meridian Drive / Greensboro, NC 27434 / Tel: (252) 757-0333

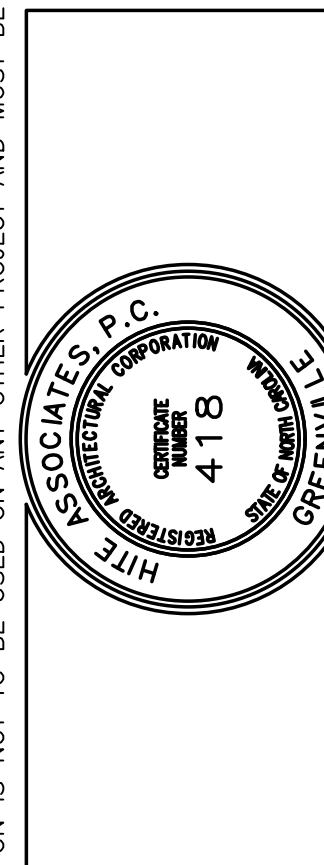

New Additions & Renovations to  
**West Carteret High School**  
4700 Country Club Road, Morehead City NC 28577  
Carteret County Schools / North Carolina

Project No. 22112  
Date: 03 Oct 2023  
Drawing no. **M 501**

THIS DRAWING IS THE PROPERTY OF ENGINEERING SOURCE OF NC, P.A. THIS DRAWING IS NOT TO BE COPIED OR THE INFORMATION HEREON IS NOT TO BE USED ON ANY OTHER PROJECT AND MUST BE RETURNED TO ENGINEERING SOURCE OF NC, P.A. UPON REQUEST. DO NOT SCALE THESE DRAWINGS; REFER TO ARCHITECTURAL DRAWINGS FOR EXACT DIMENSIONS.